



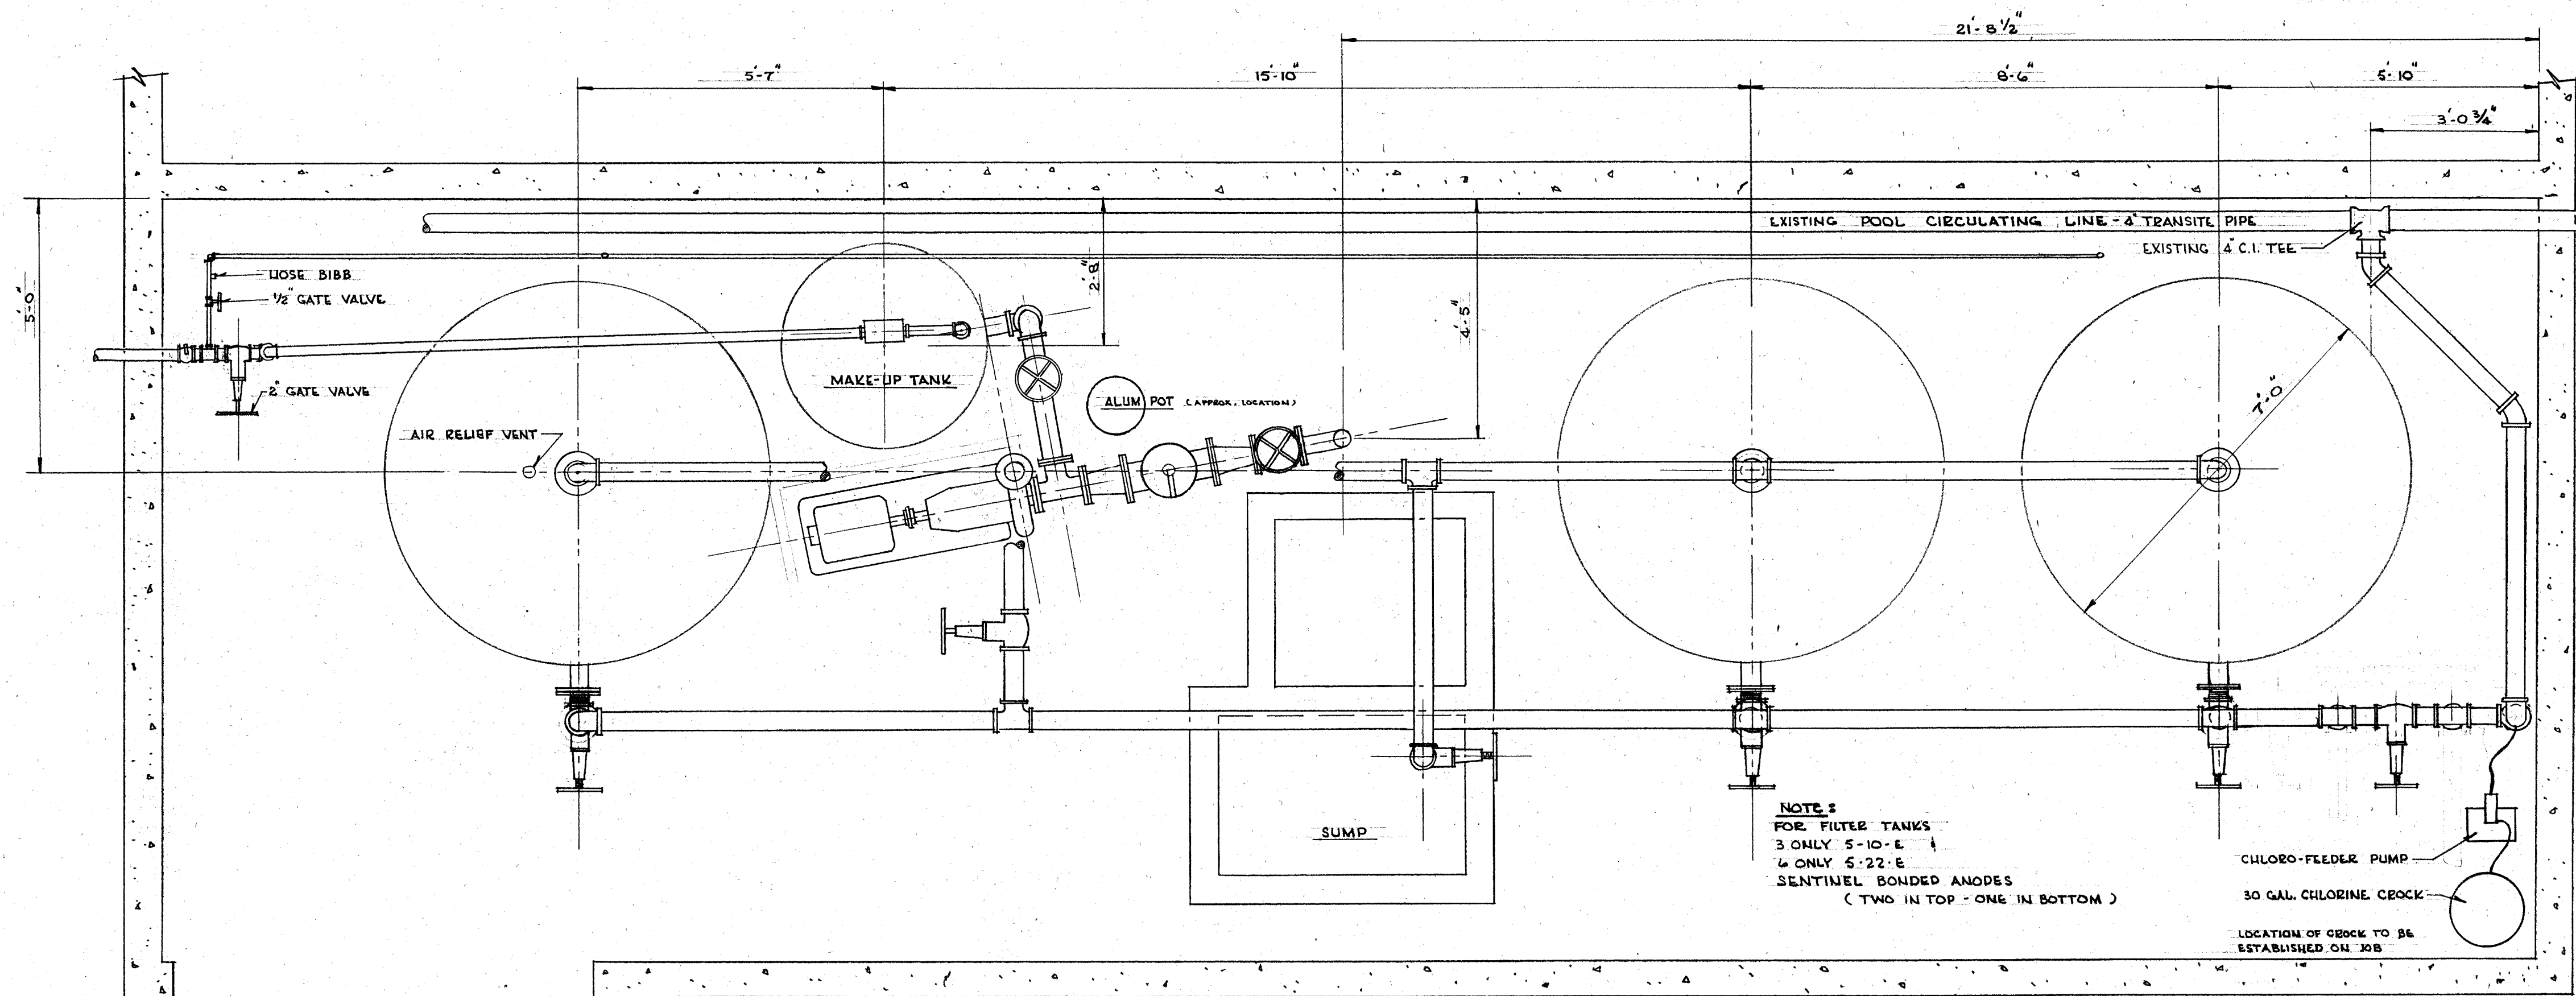

PLAN

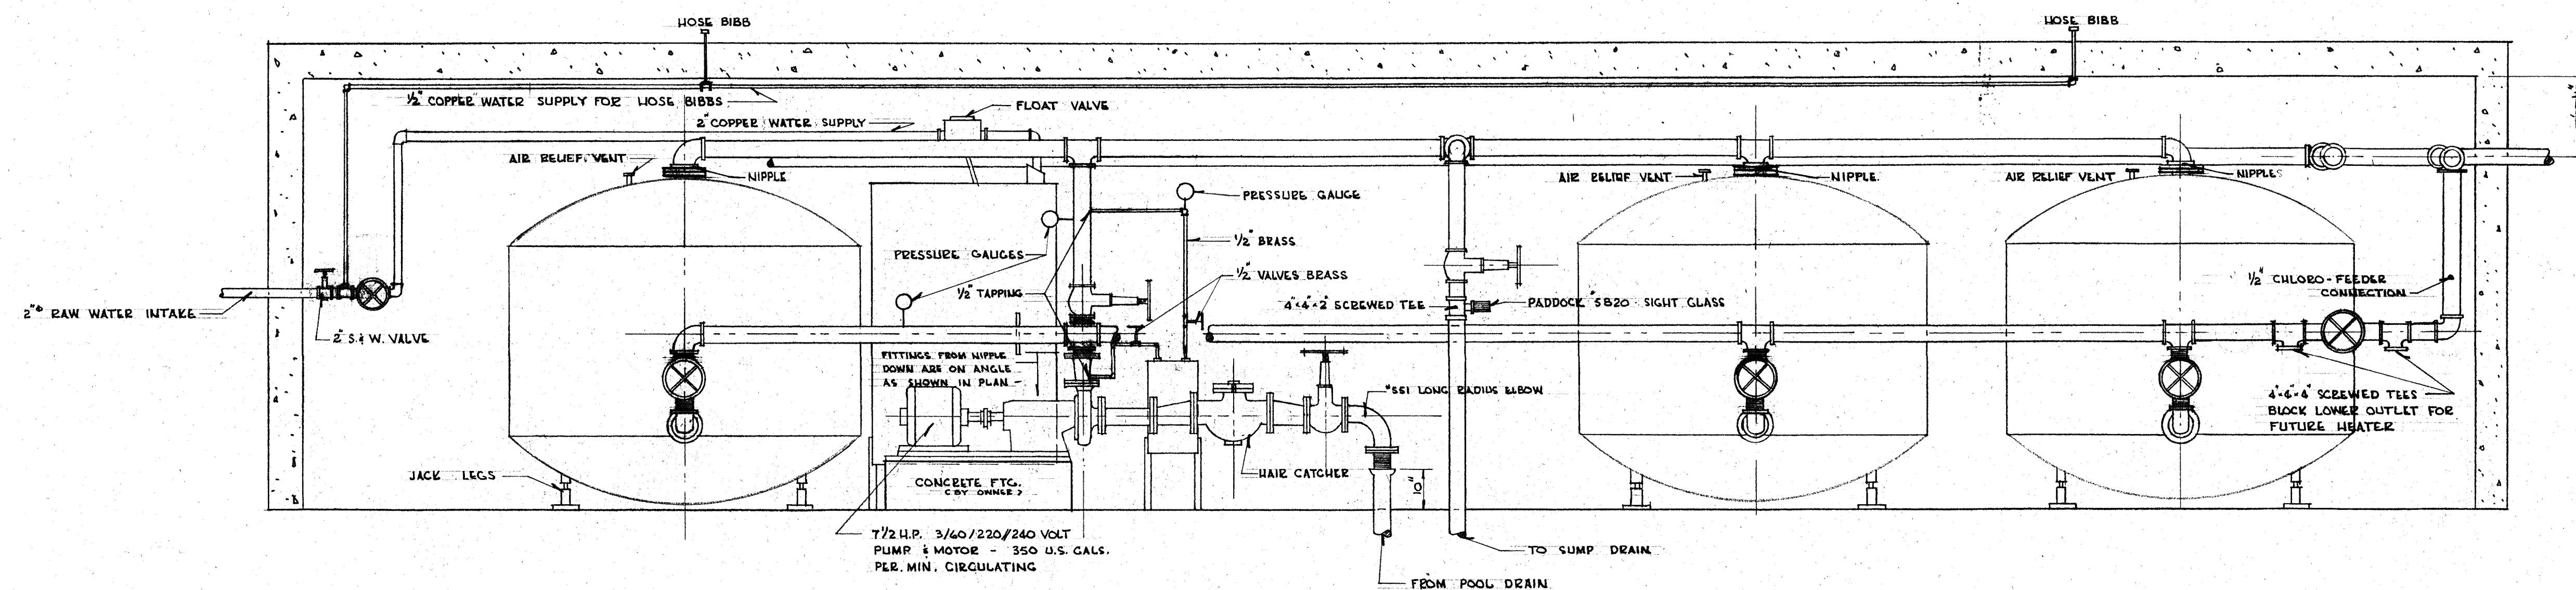

ELEVATION

MATERIAL	
NUMBER	DESCRIPTION
1	CRANE 551 LONG RADIUS 4' ELBOW - FLANGED
2	548 4" ECCENTRIC REDUCERS - FLANGED
1	547 4" TAPER REDUCER - FLANGED
1	445 4" GATE VALVE - FLANGED
1	444 4" SCREWED GATE VALVES
1	529 4" 4" 4" TEE - FLANGED
9	4" 4" 4" SCREWED TEES
1	4" 4" 2" SCREWED TEE
11	4" 4" SCREWED 90° ELBOWS
2	4" 4" SCREWED 45° ELBOWS
3	1/2" SCREWED GATE VALVES
1	2" SCREWED GATE VALVE
6	4" SCREWED COMPANION FLANGES
1	2" STOP & WASTE VALVE
1	CLAYTON 124 2" AUTOMATIC FLOAT VALVE
3	3/4" HOSE BIBBS
* 3	MORRISON 4674 PRESSURE GAUGES
* 1	PADDOCK 5820 SIGHT GLASS
* 3	ARMSTRONG 21" AR - 125" AIR RELIEF VALVE
* 1	PROPOSITIONEES HEAVY DUTY MIDGET CHLORO-FEEDER PUMP
* 1	30 GAL. CHLORINE CROCK
* 1	ALUM PRESSURE POT
* 1	A.S. LEITCH 6" ASS C - MODEL 50BC 3" 4" CENTRIFUGAL PUMP
* 1	M'ALEER 9" 52B 4" BOLTED COVER TYPE VALVE CATCHER
* 3	84" DIAMETER STEEL FILTER TANKS WITH 4 JACK LEGS PER TANK
* SUPPLIED BY GENERAL EQUIPMENT	
USE 125" STANDARD BLACK PIPE & FITTINGS	

REV. DATE BY DESCRIPTION

"AS-BUILT" DRAWING

This drawing is for reference use only. The City of Vancouver does not guarantee nor is responsible for its accuracy. Users are advised to verify all information on site.

CITY OF VANCOUVER
BOARD OF PARKS AND RECREATION

A1 149.004/02 -6

PIPING LAYOUT FOR FILTER ROOM

KERRISDALE SWIMMING POOL

BOARD OF PARKS AND PUBLIC RECREATION

 









STANLEY PARK - VANCOUVER B.C.

DRAWN BY: R.F.W.
CHECKED BY: L.R.

SCALE: 1/2\"/>

DATE: APRIL 1956

FILE NO.

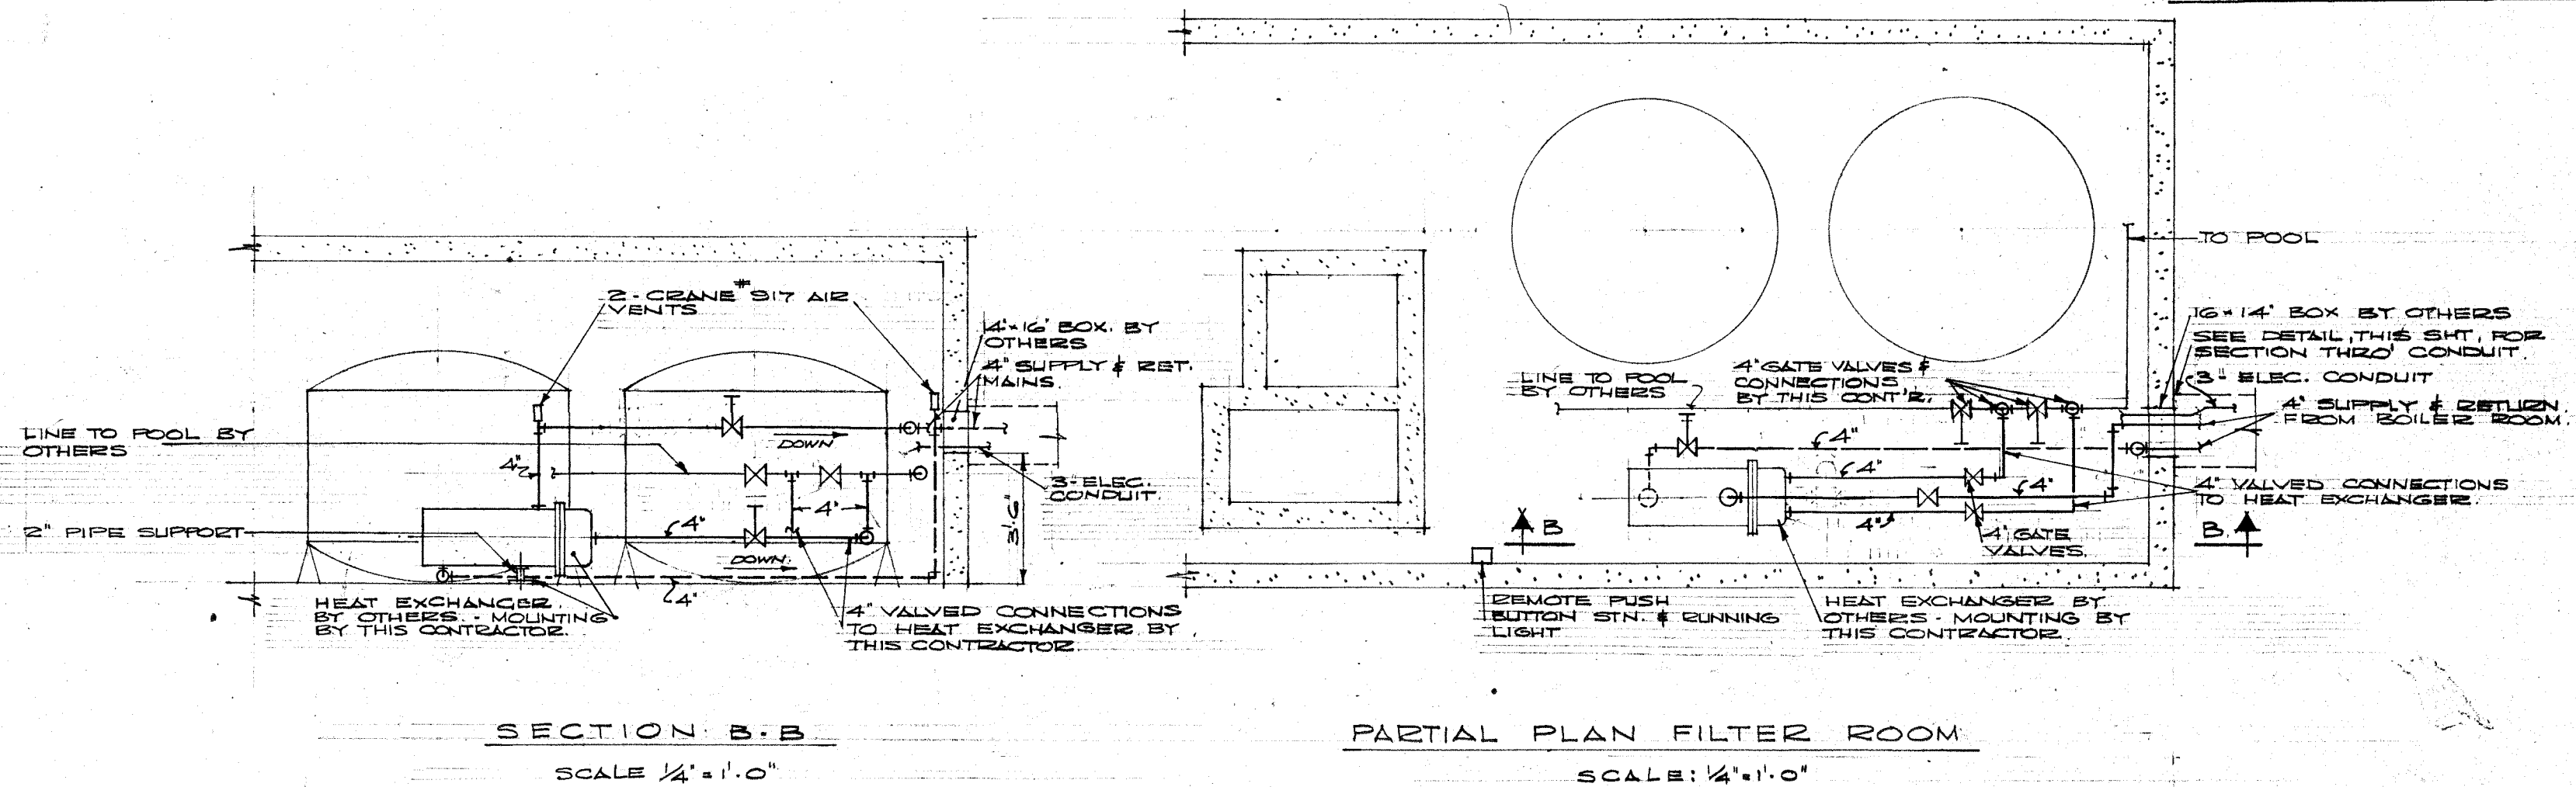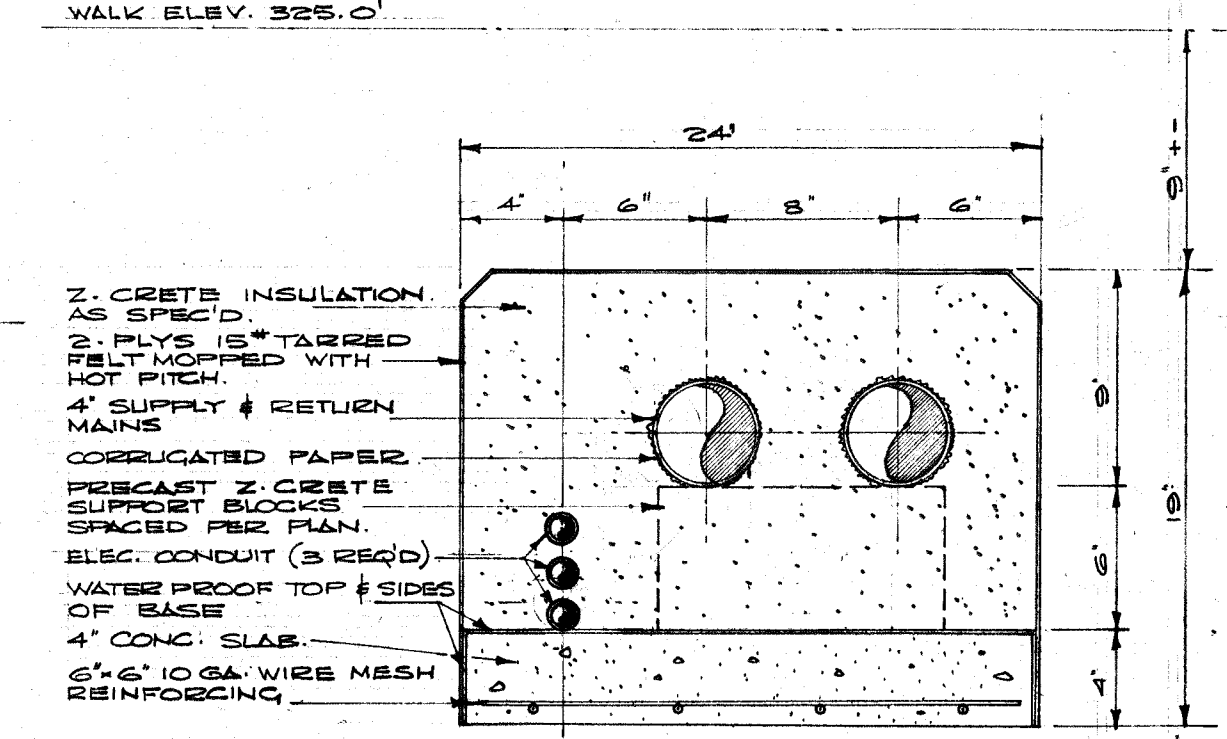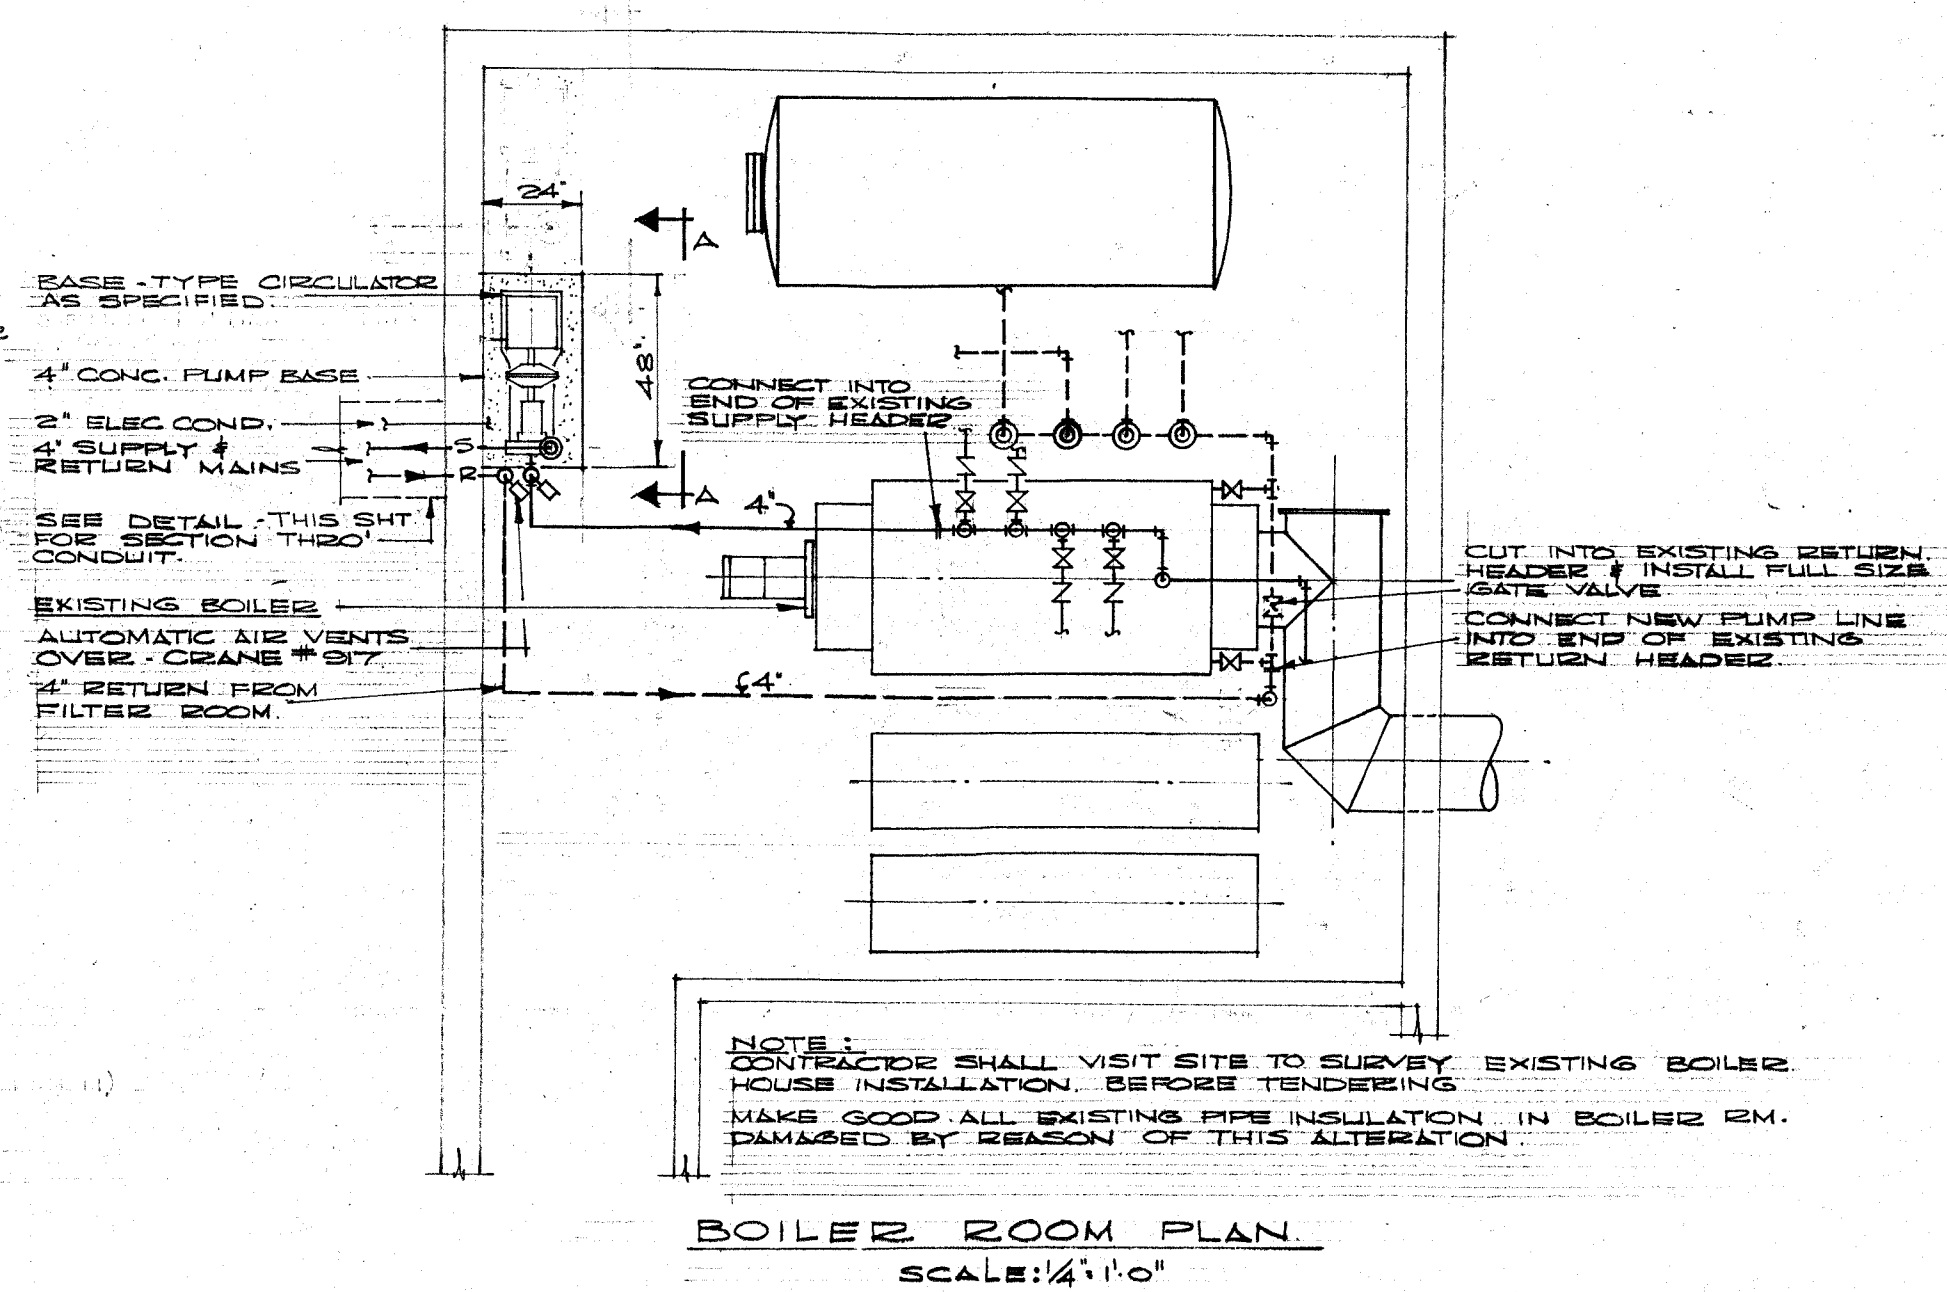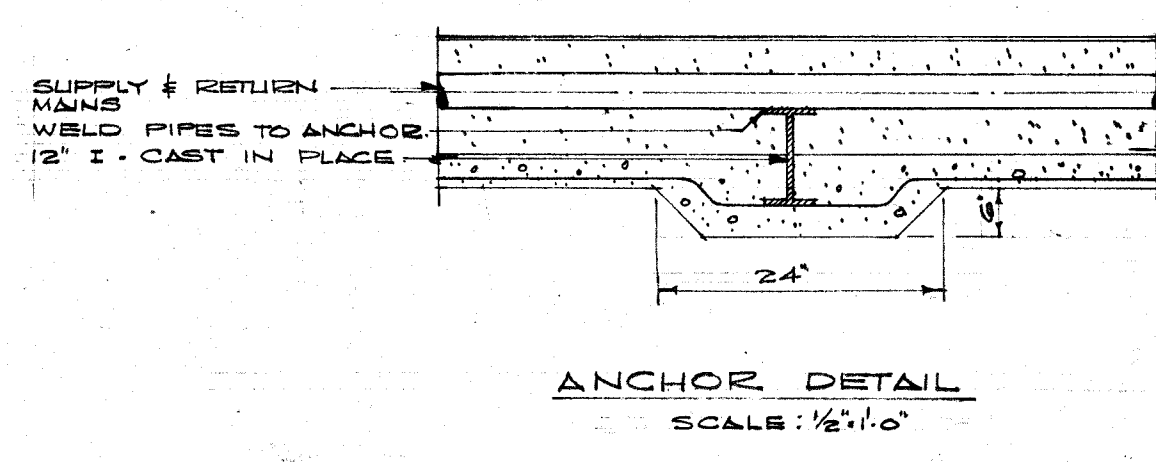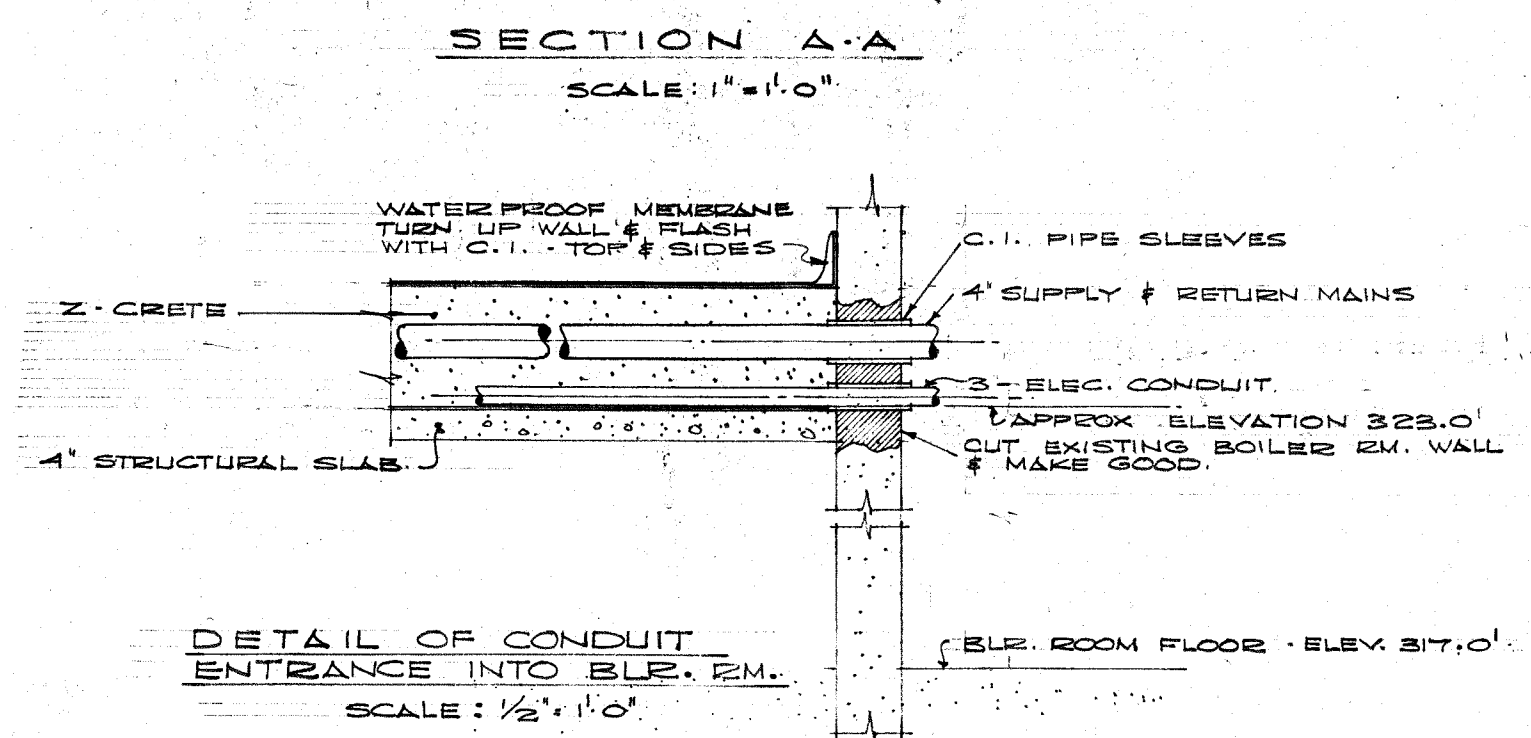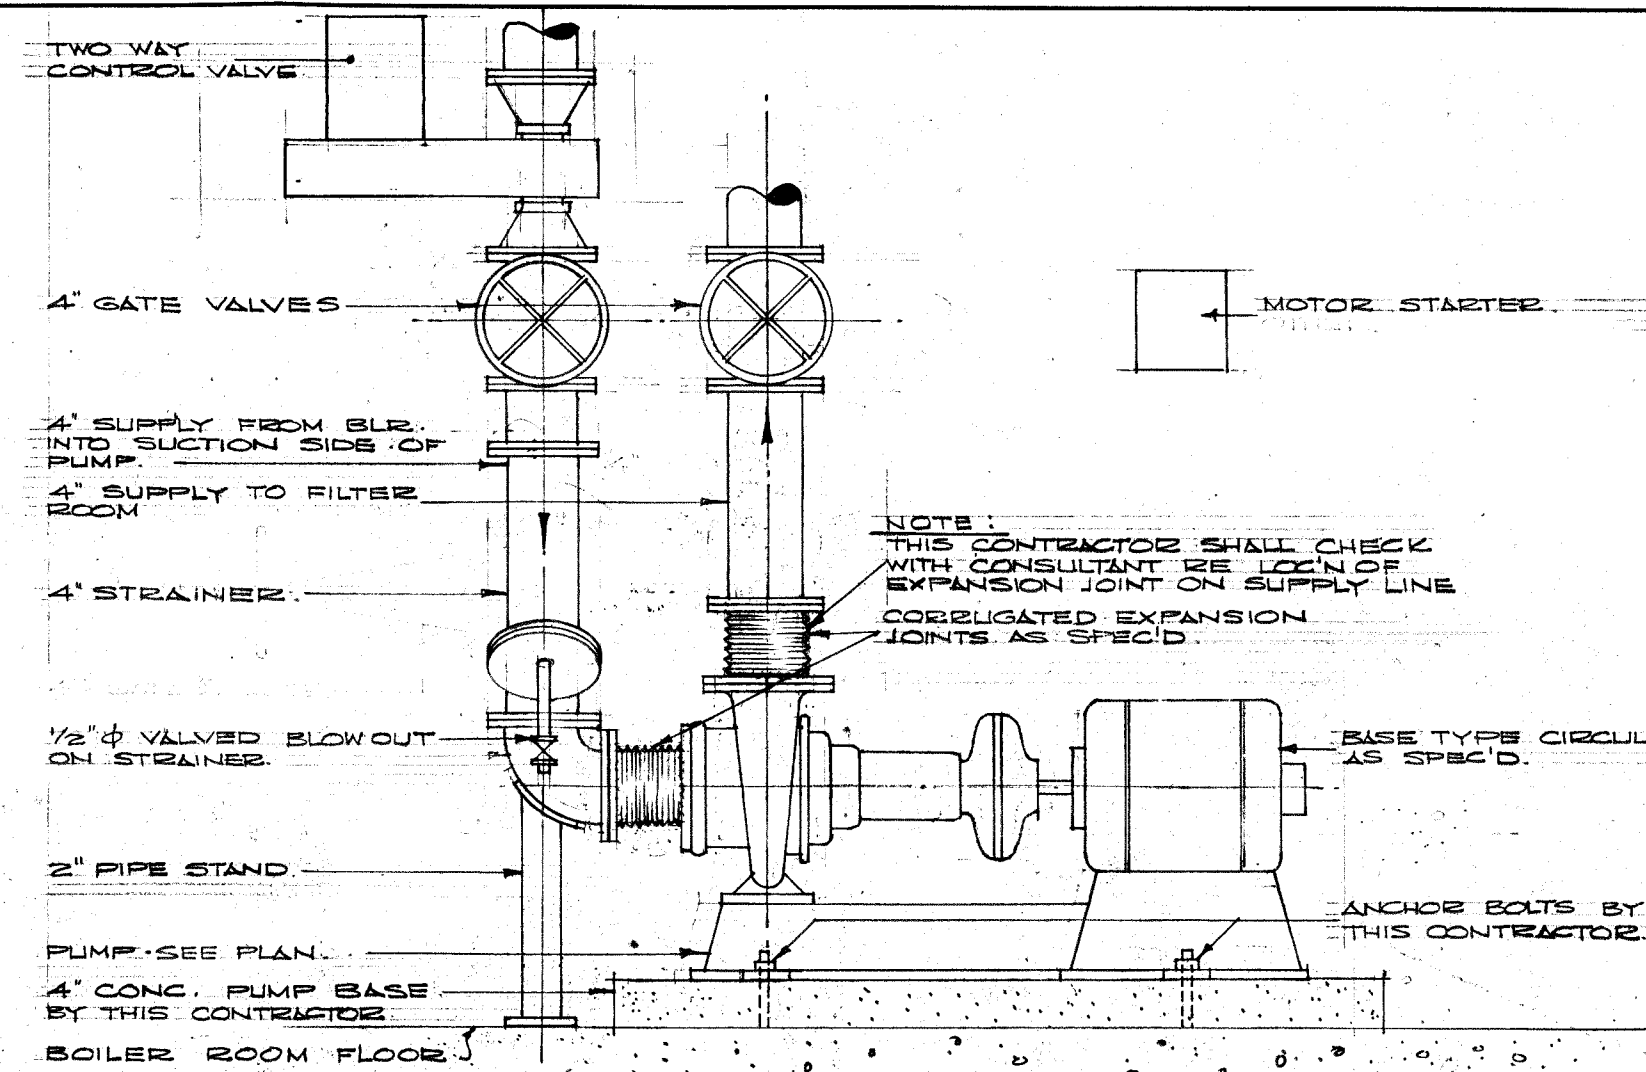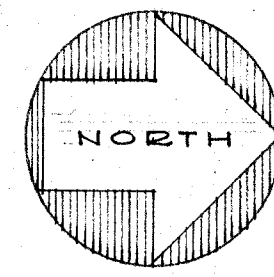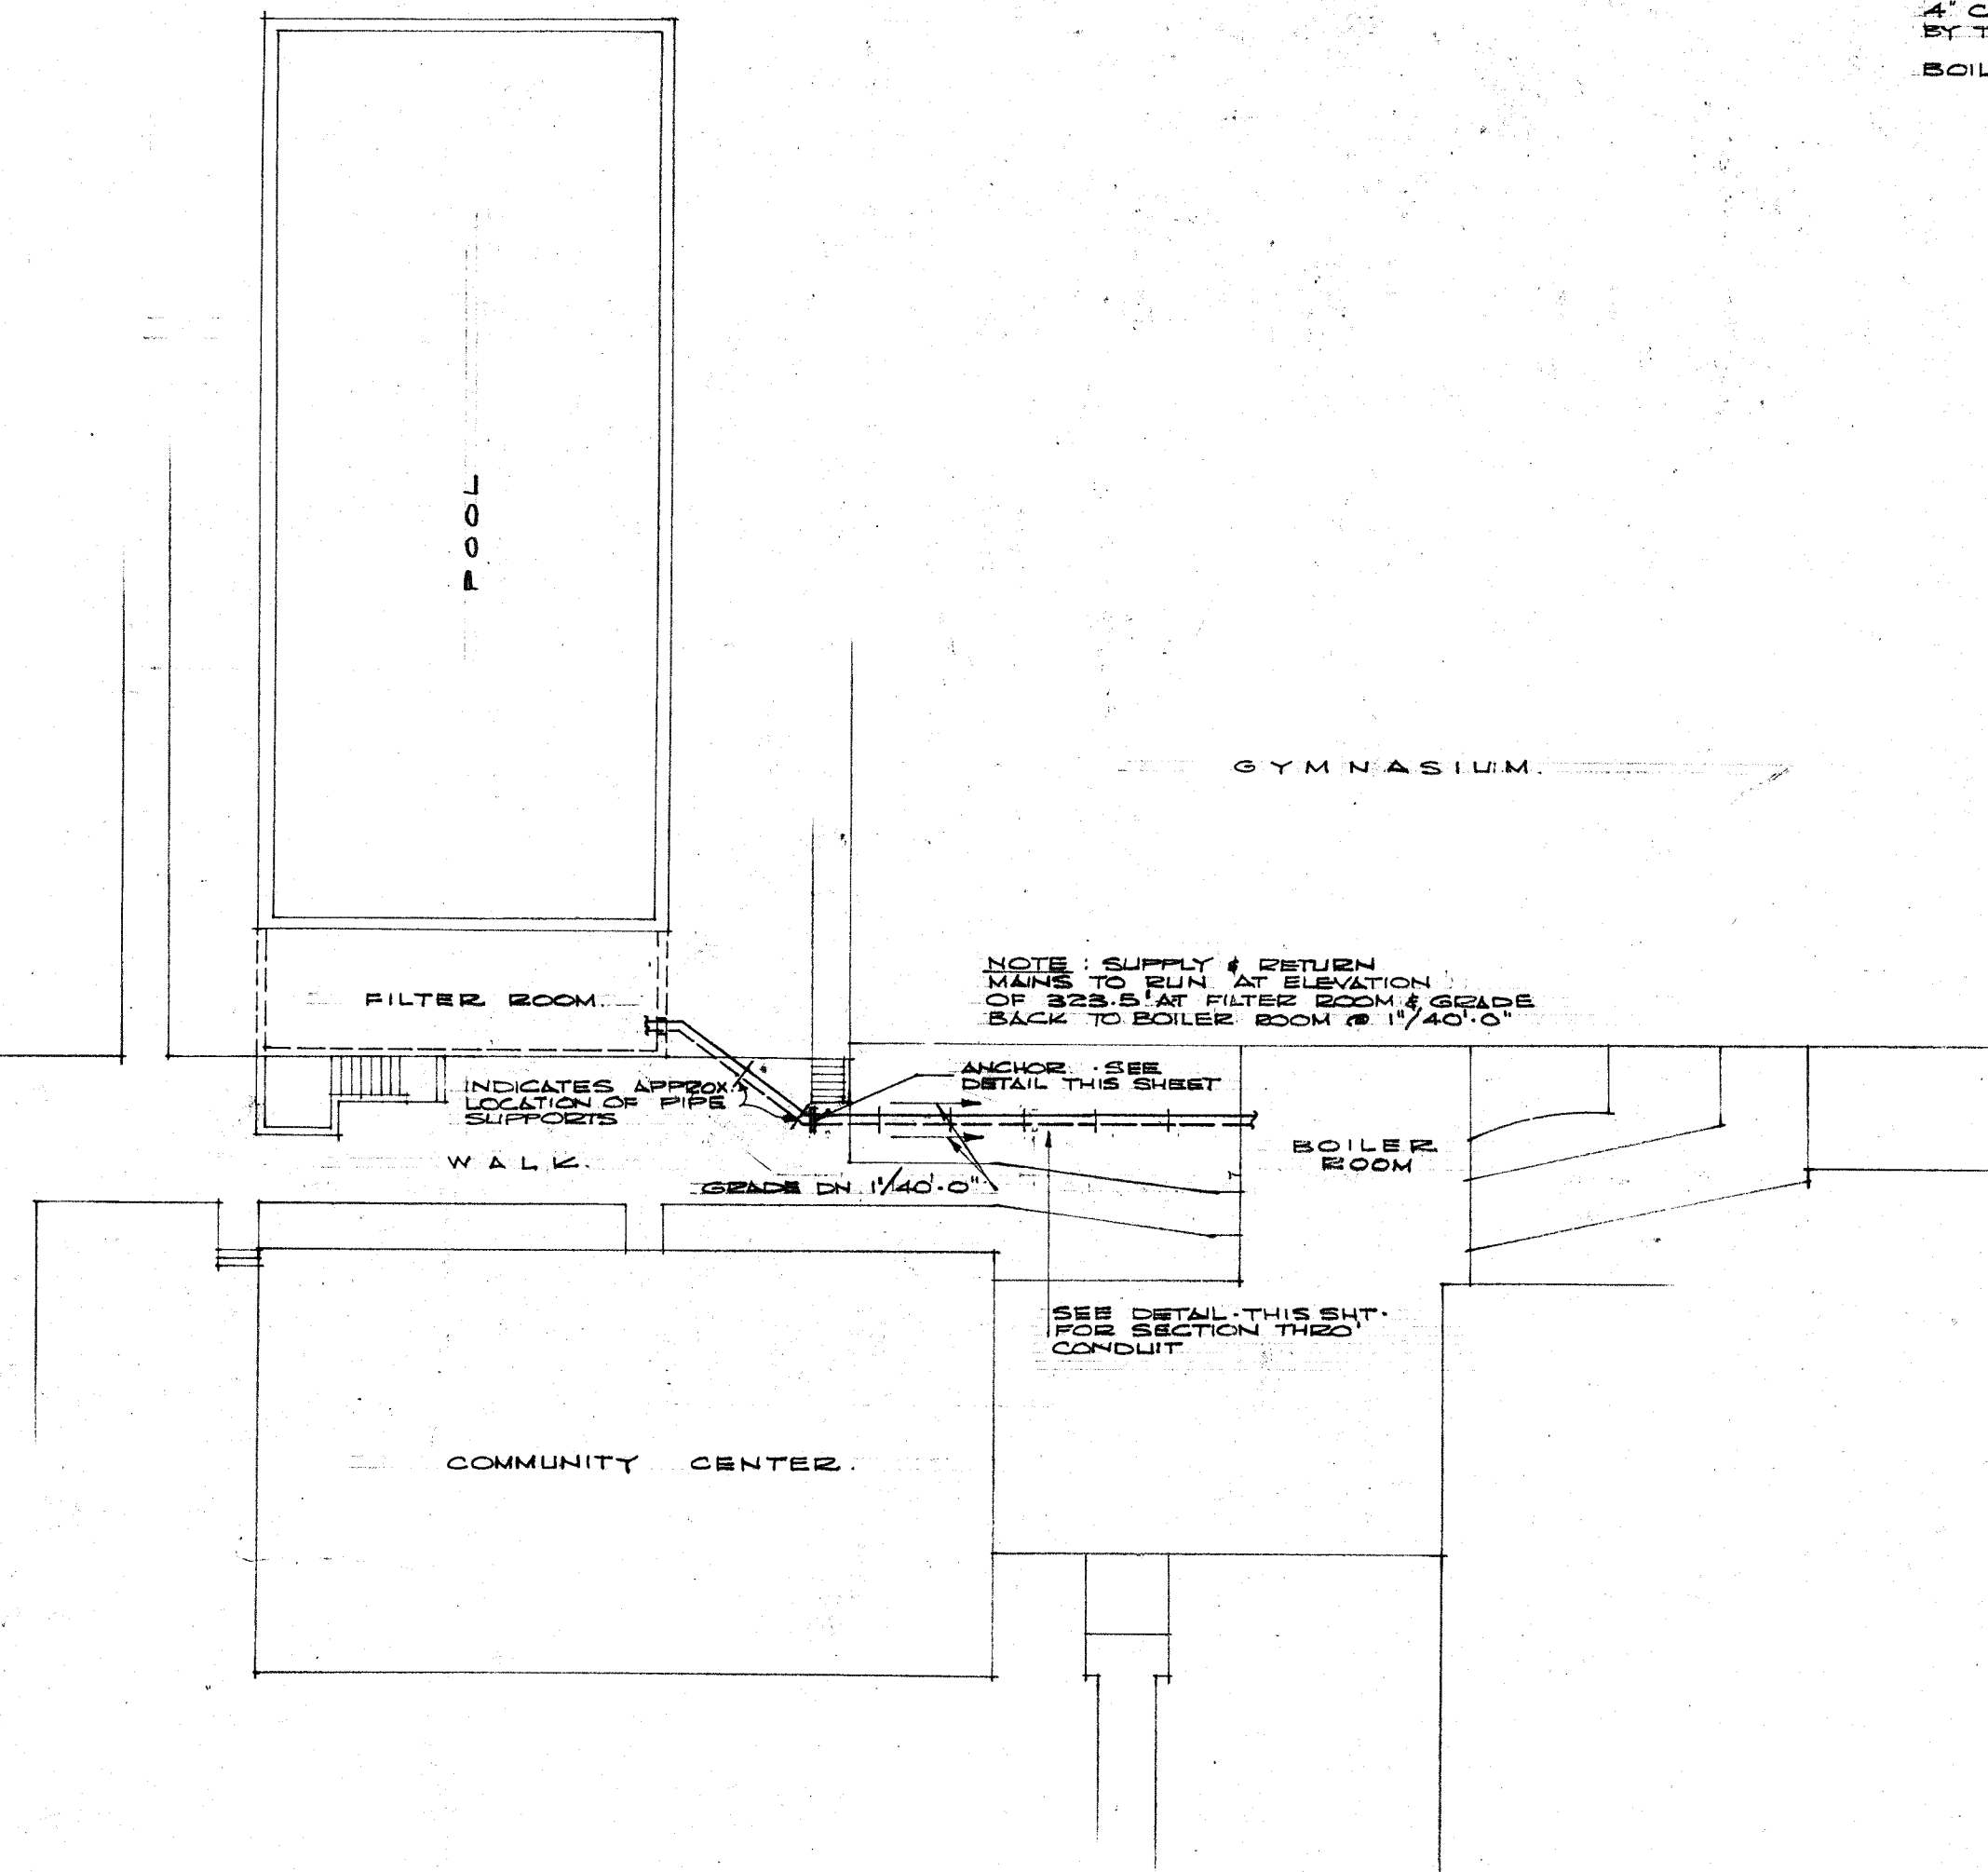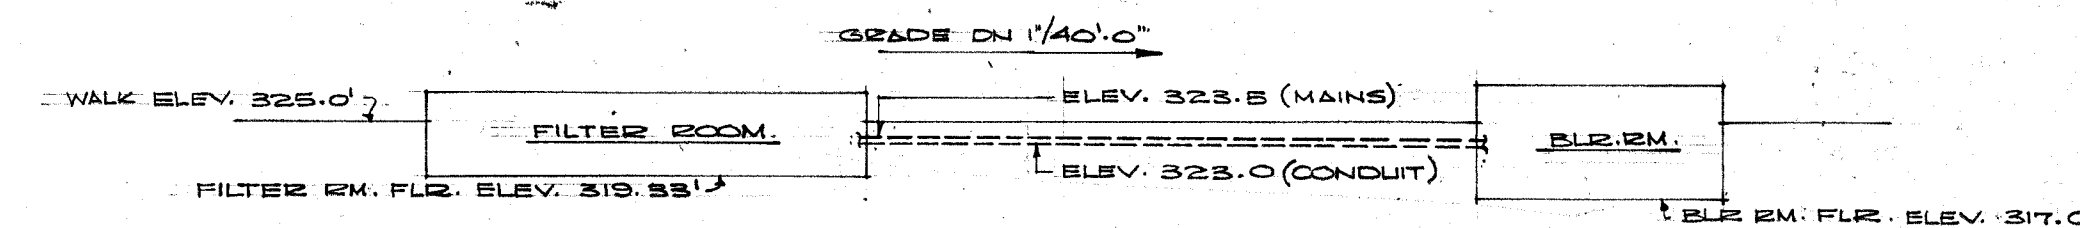

REV.	DATE	BY	DESCRIPTION
1			"AS-BUILT" DRAWING
This drawing is for reference use only. The City of Vancouver does not guarantee nor is responsible for its accuracy. Users are advised to verify all information on site.			
CITY OF VANCOUVER BOARD OF PARKS AND RECREATION			

HEAT AND POWER
ENGINEERING LTD.
16 EAST HASTINGS ST.
VANCOUVER, B.C.
JOB NO. 418 DRWG NO. 1418-A

SWIMMING POOL FOR
KERRISDALE COMMUNITY CENTRE
SHEET M1 OF 1
SITE PLAN & DETAILS
BOARD OF PARK COMMISSIONERS
STANLEY PARK VANCOUVER, B.C.
DATE: APRIL 4/86
DRAWN BY: B.S. FILE
CHECKED BY: E.M.

GRILLE, REGISTERS & DIFFUSERS					
MARK	USE	TYPE	DAMPER	FINISH	SIZE
SR-1	SUPPLY	CS-212 SK	AG-75	ALUM.	AS NOTED
SD-1	SUPPLY	TMSA-3	AG-75	ALUM.	12"x12" MODULE
SD-2	SUPPLY	TMSA-1	AG-75	ALUM.	24"x24" MODULE
ER-1	EXHAUST	CL-35 KC	AG-35	ALUM.	AS NOTED
RG-1	RETURN	CL-35 KC	AG-35	ALUM.	AS NOTED
(A)	DOOR	34" DOOR UNDERCUT	—	ALUM.	12"x16"
(C)	DOOR	T-900A	—	ALUM.	12"x16"


EXHAUST FANS									
MARK	SERVICE	MODEL	C.F.M.	S.P.	H.P.	R.M.	TIP SPEED	SONES	NOTES
EF-1	WASH RM 113	CBE-14-4	950	.25	1/4	720	2730	5.5	
EF-2	WASH RM 108	S.P. 17	150	.15	1/50	1550	—	3.2	2.
EF-3	WASH RM 104	S.P. 17	150	.15	1/50	1550	—	3.2	2.
EF-4	CONTROL 103	S.P. 17	150	.15	1/50	1550	—	3.2	2.

NOTES


1. FANS ARE TO BE 'GREENHECK' OR APPROVED EQUAL
2. FANS C/W WEATHERPROOF WALL DISCH. HOOD.

NOTES


1. SHOWER EXHAUST DUCTWORK AND POOL SUPPLY DUCTWORK TO BE FABRICATED FROM ALUM. WITH METAL GAUGE IN ACCORDANCE WITH S.M.A.C.N.A. RECOMMENDATIONS.
2. ELECTRIC HEATERS ARE TO BE CHROMALOX MODEL BB OR APPROVED EQUAL COMPLETE WITH INTEGRAL THERMOSTATS. DOOR HEATER TO BE MODEL EF-1 TAMPER PROOF SURFACE MOUNTED WALL HEATER 125848A WITH BUILT IN THERMOSTAT. HEATERS ARE TO BE PROVIDED BY MECHANICAL CONTRACTOR AND WIRED BY ELECTRICAL CONTRACTOR.
- HEATERS ARE TO BE SUITABLE FOR 208/1160 POWER.
3. CEILING MOUNTED FAN HEATERS ARE TO BE 'FFE' SERIES 28-152-124-101 CEILING RECESSED, 208/1160 POWER, 24V 120 VOLT WALL MOUNTED THERMOSTATS. PROVIDE 1/2" X 200 AND HARDWARE FOR MOUNTING UNITS FROM ROOF. AND HEAVY DUTY THERMOSTAT GUARDS.

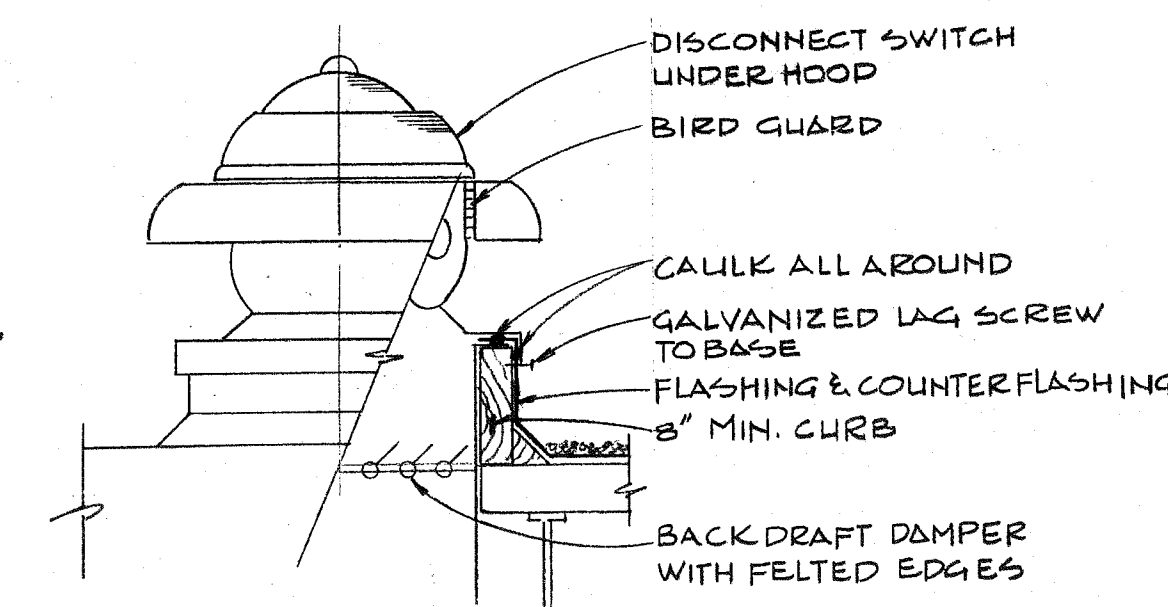


ROOF EXHAUST FAN
N.T.S.

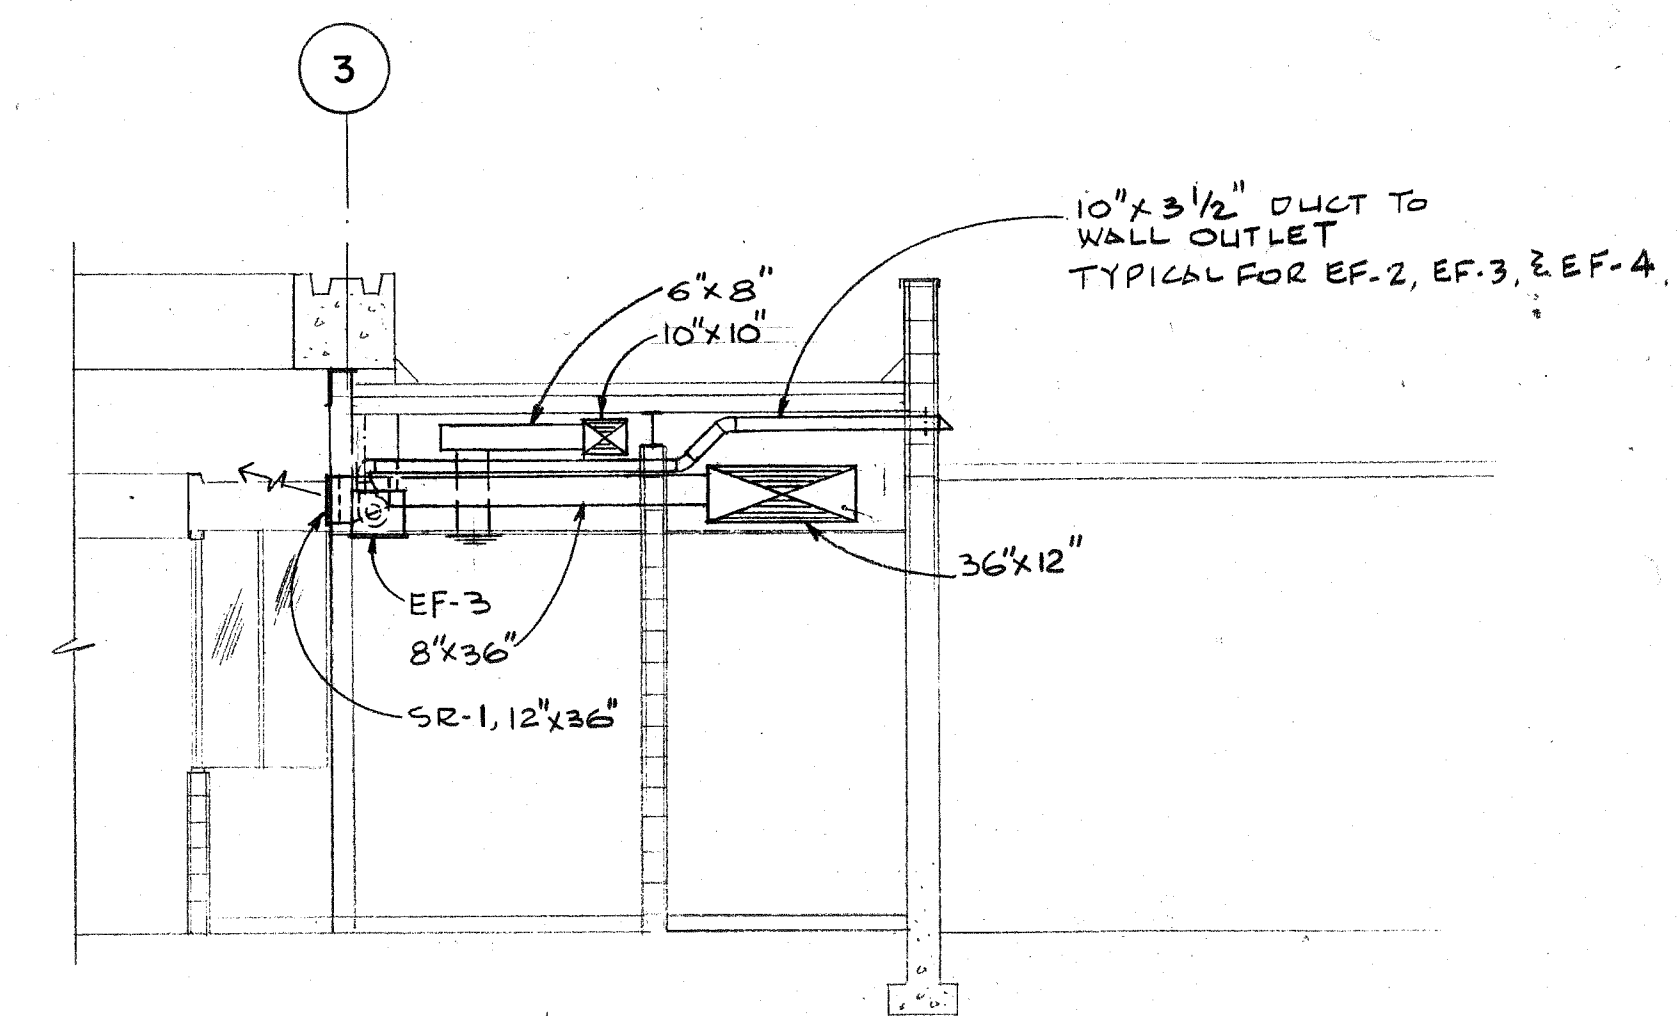


SECTION
1/4" = 1' - 0"

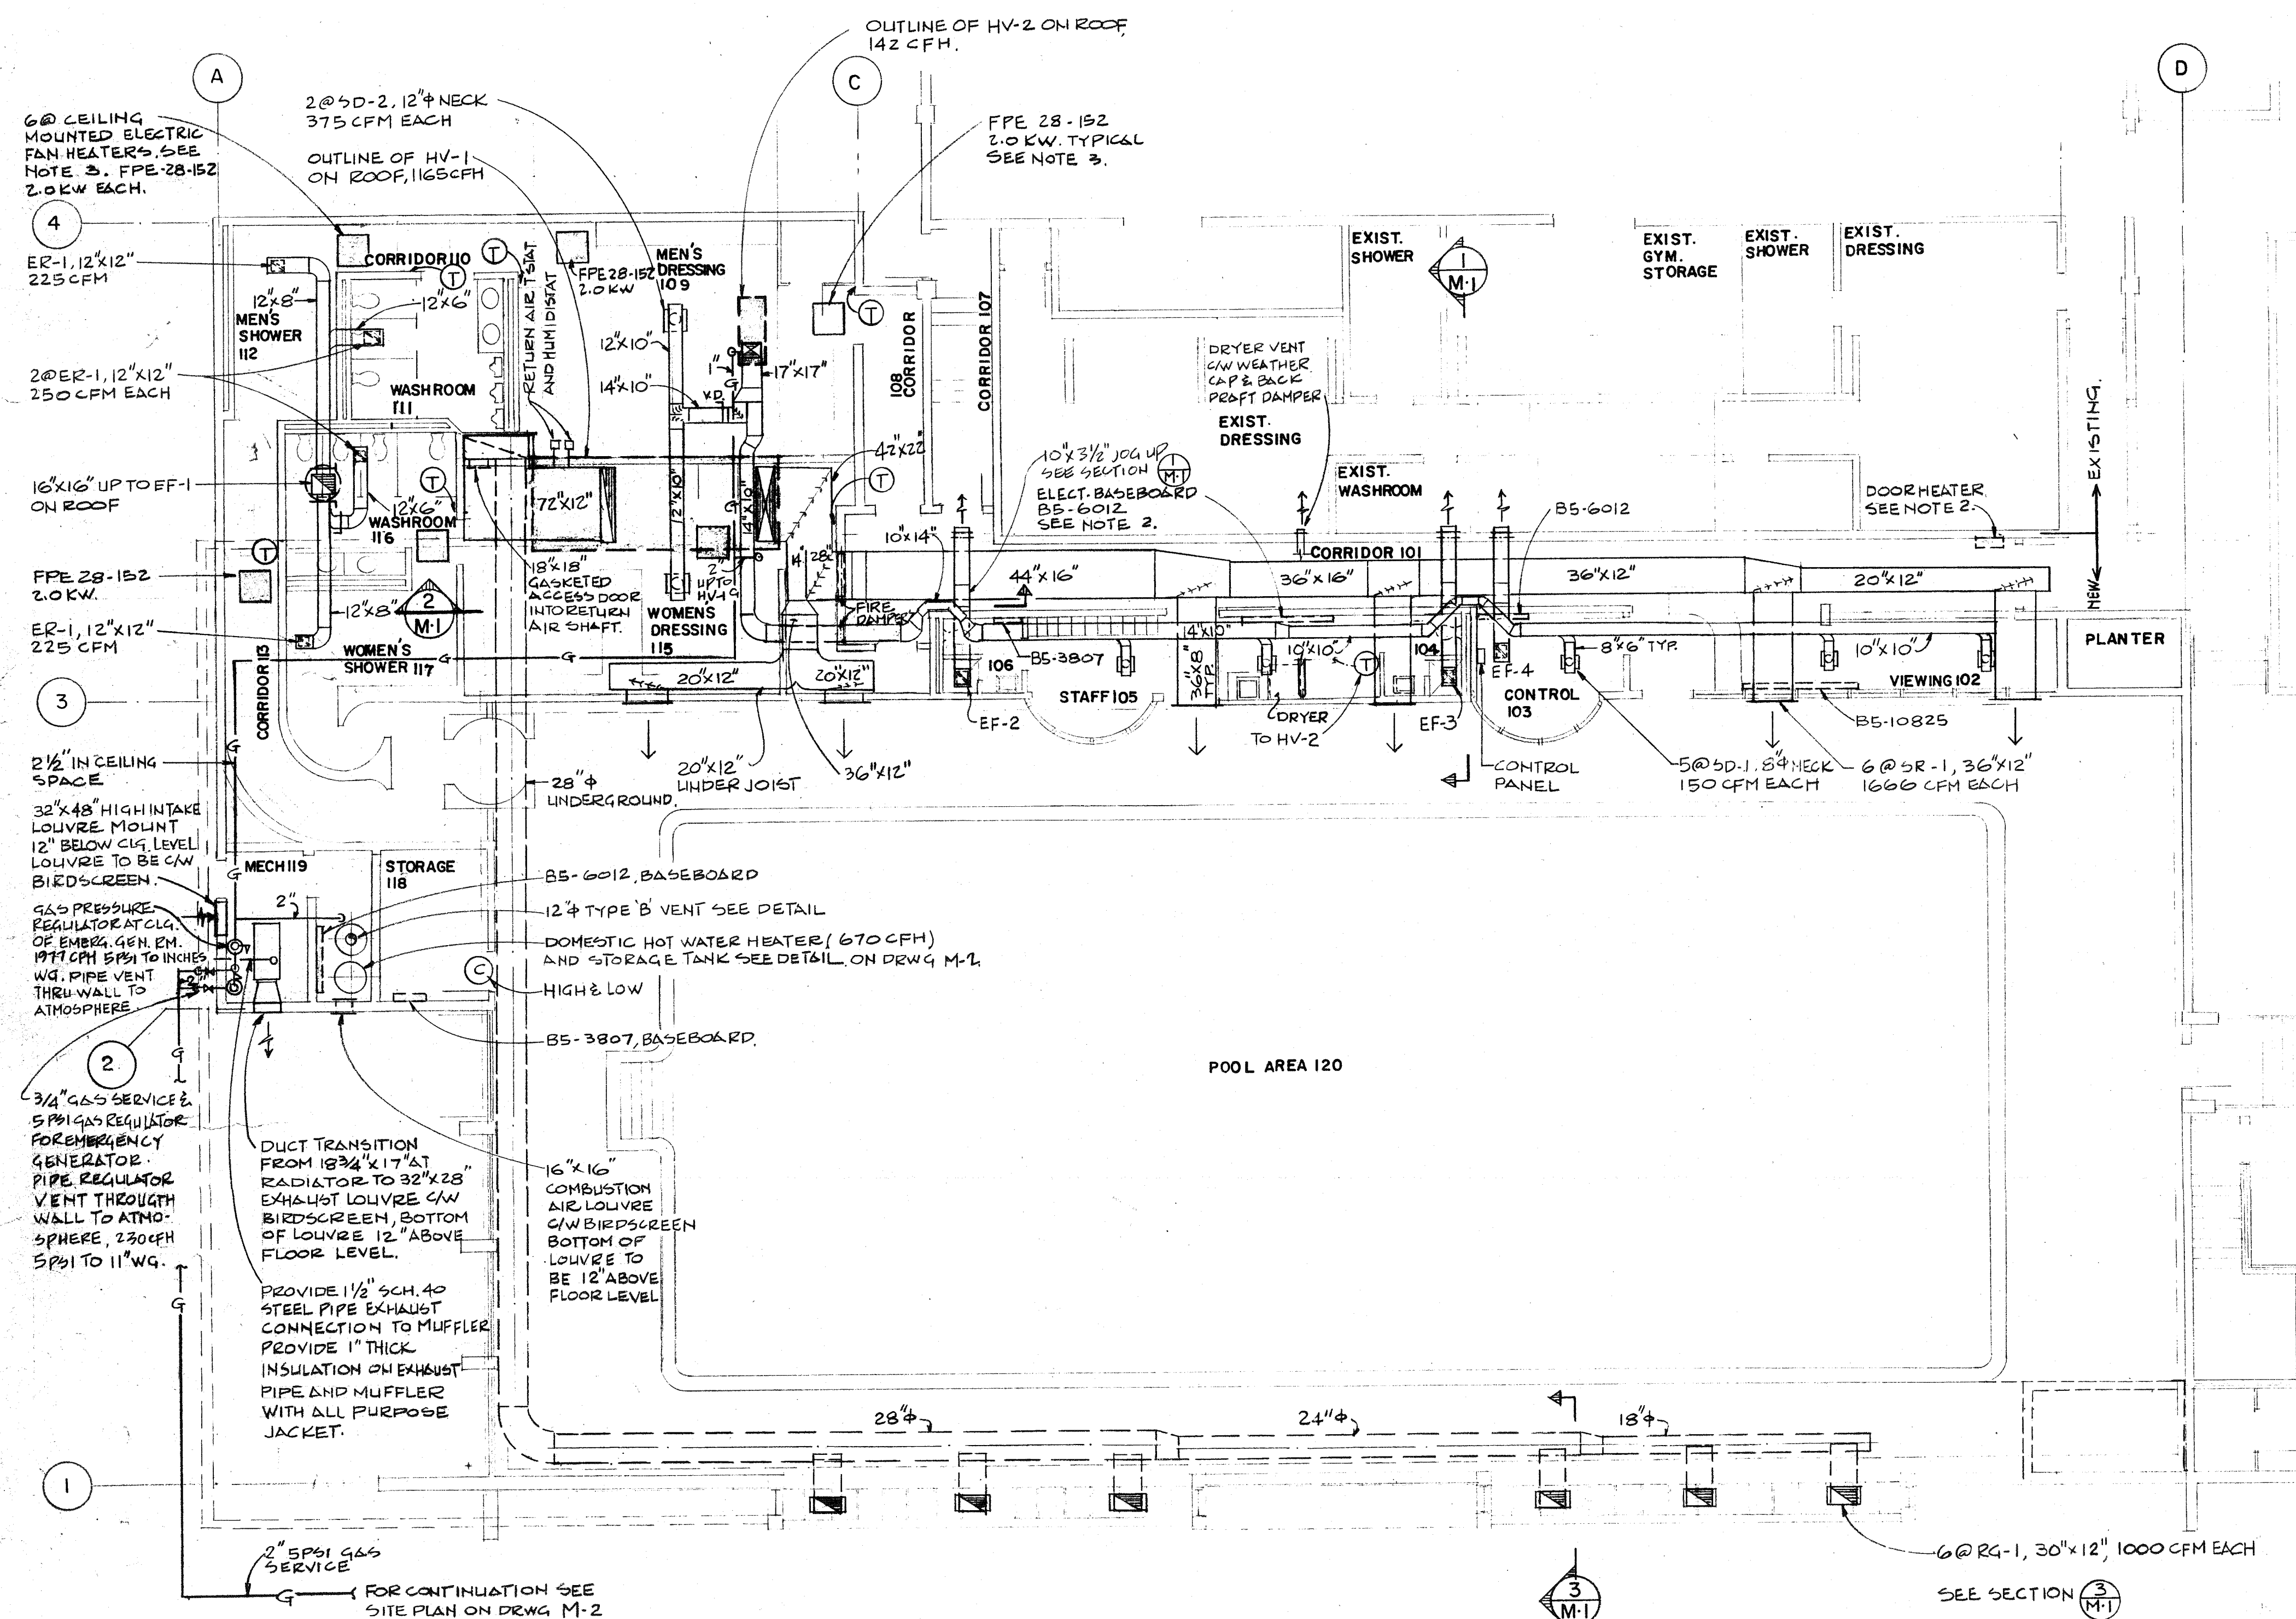


FLOOR PLAN FLOOR ELEV. 328'-5"
1/8" = 1' - 0"

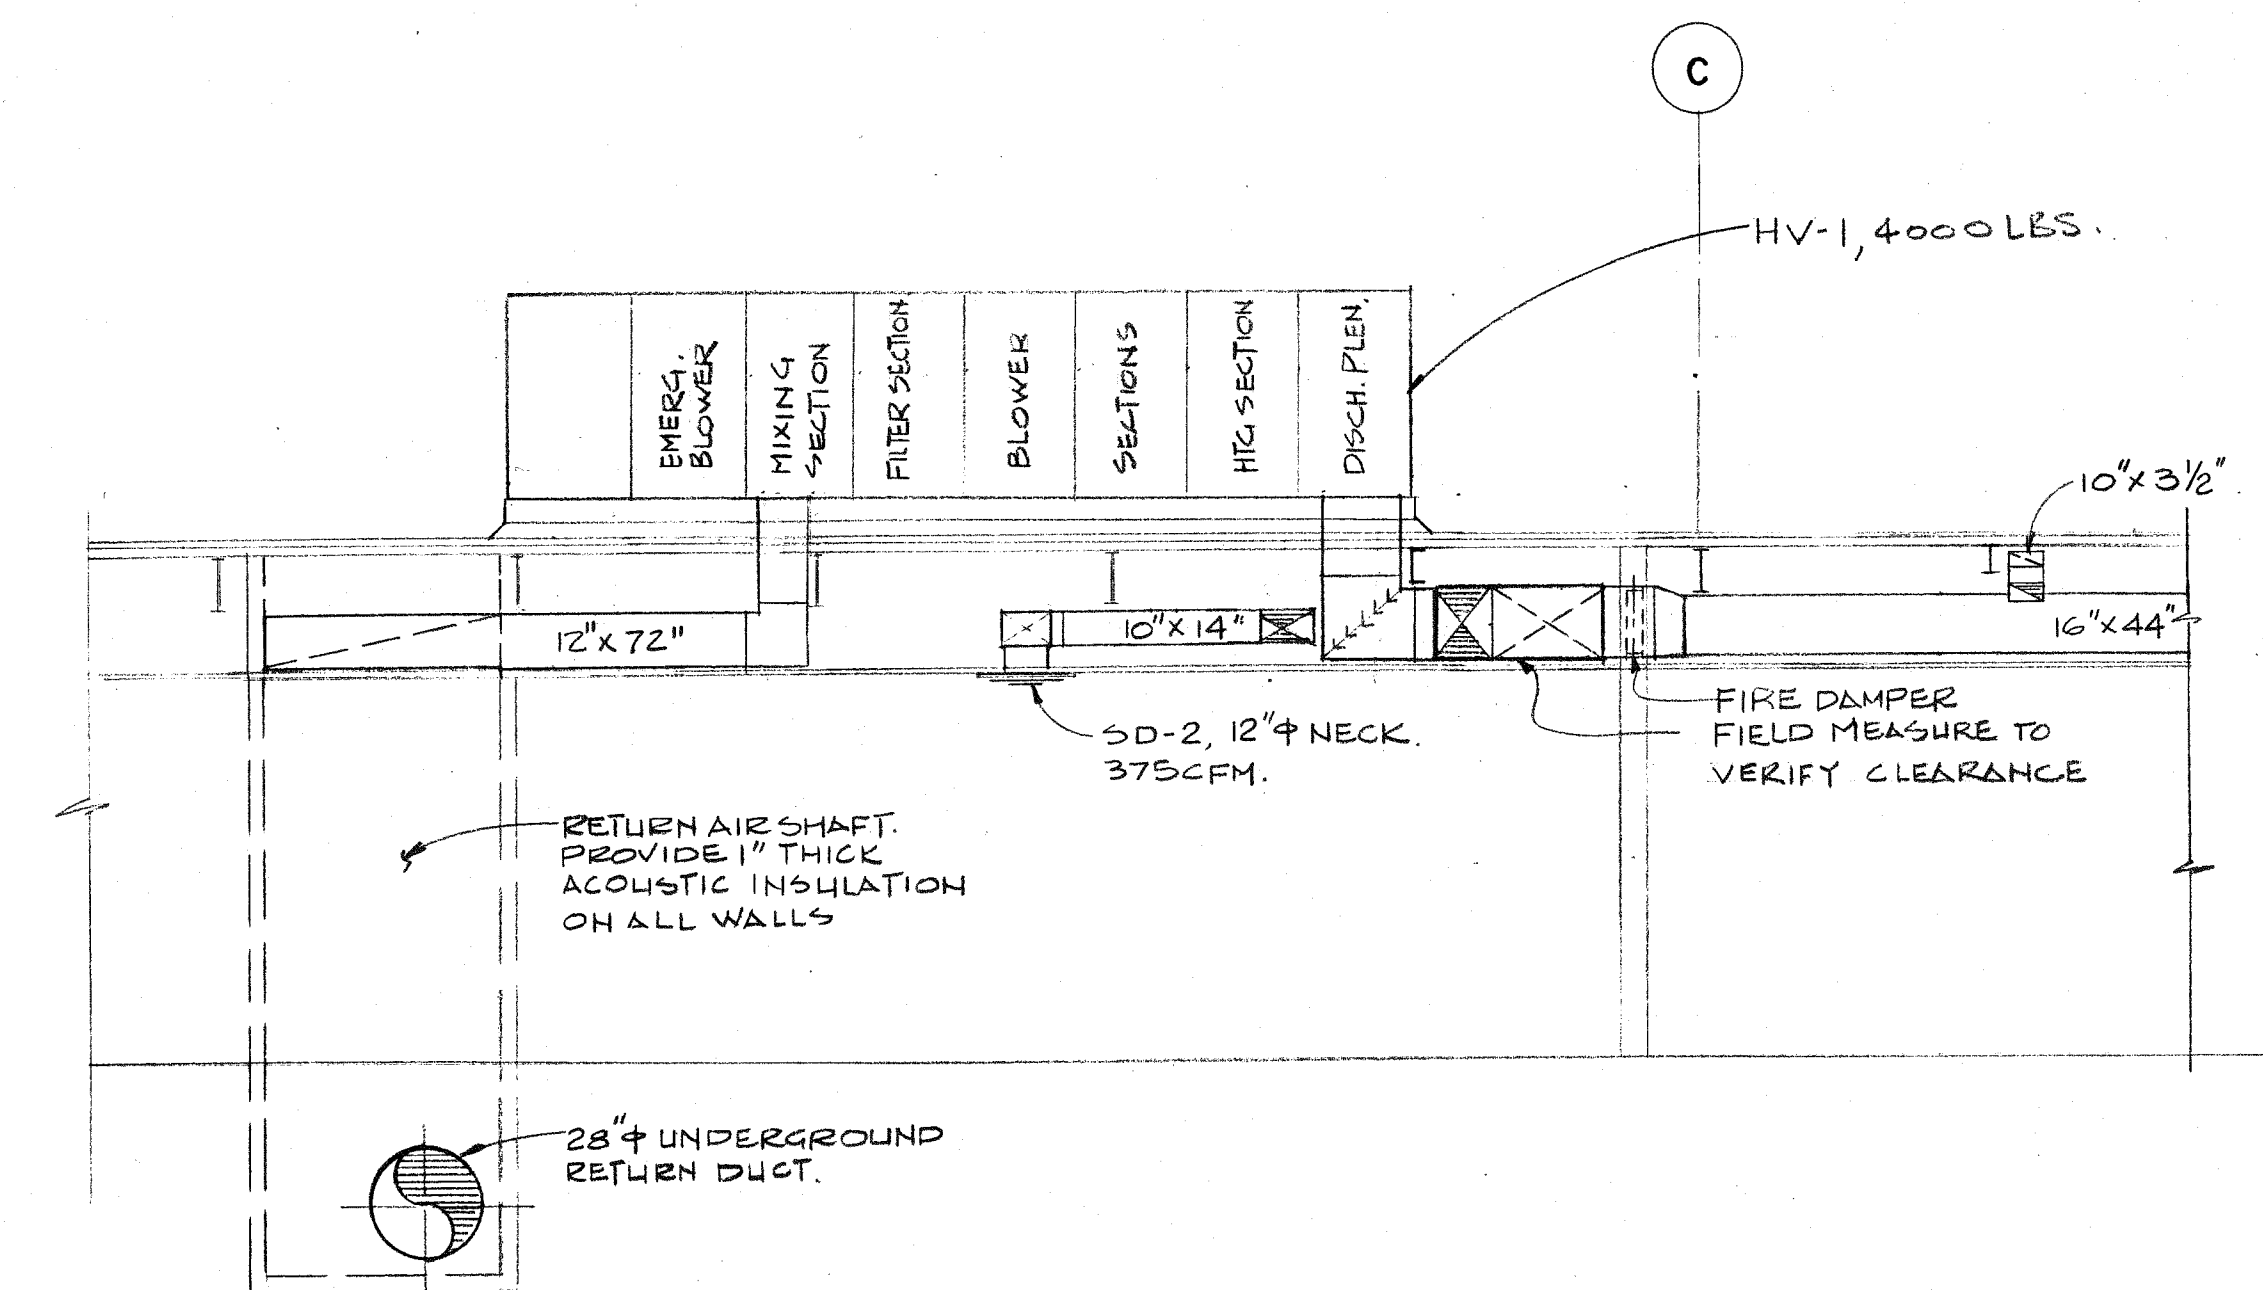

SECTION
1/4" = 1' - 0"

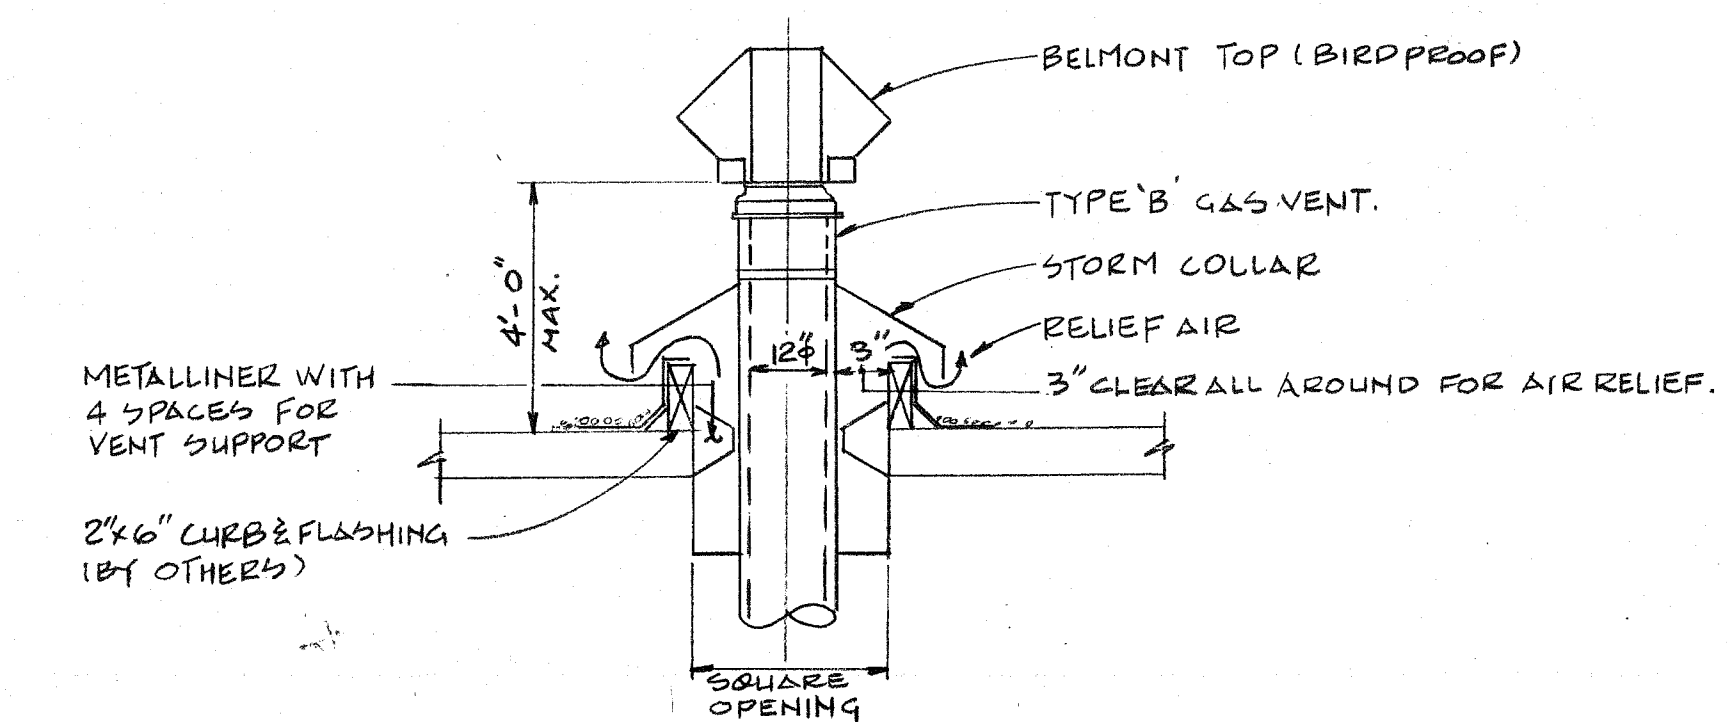

GAS VENT & RELIEF AIR DETAIL
N. T. S.

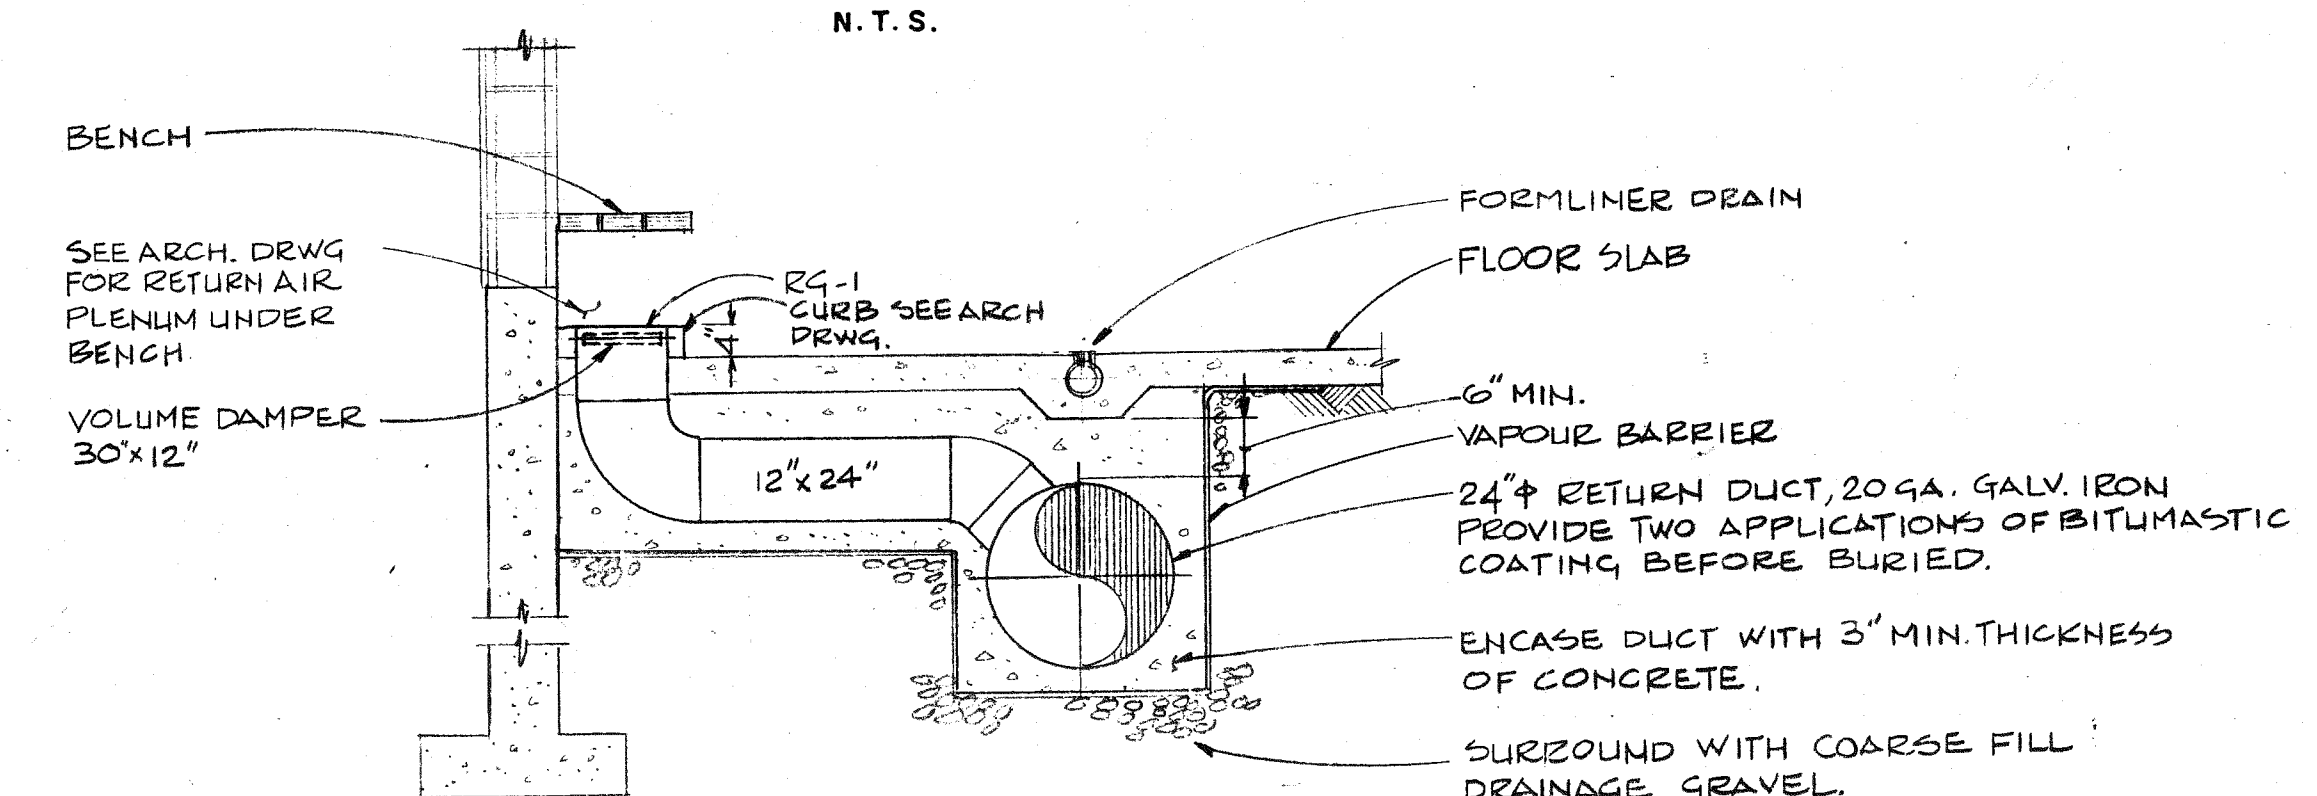

SECTION 3
1/2" = 1' - 0"

REV.	DATE	BY	DESCRIPTION
"AS-BUILT." DRAWING This drawing is for reference use only. The City of Vancouver does not guarantee nor is responsible for its accuracy. Users are advised to verify all information on site. CITY OF VANCOUVER BOARD OF PARKS AND RECREATION			
PULPWORK REVISED			JAN 3 1980
REVISIONS			A

J. M. BEAN & CO. LTD.
CONSULTING ENGINEERS
1965 WEST 4th AVENUE
VANCOUVER B. C.
V6J 1M8 736-6724

**CARLBERG
JACKSON
PARTNERS**
ARCHITECTS

313 SIXTH STREET
NEW WESTMINSTER
526-2764

TITLE

KERRISDALE
SWIMMING
POOL
ADDITION

5851 W. BOULEVARD
VANCOUVER, B. C.


COMM. NO. 7815	DATE 79/07/06
DRAWN	CHECK

DRAWING TITLE
FLOOR PLAN
HEATING & VENTILATING

DRAWING NO.

M-1^A OF 4

AO 149,009/0

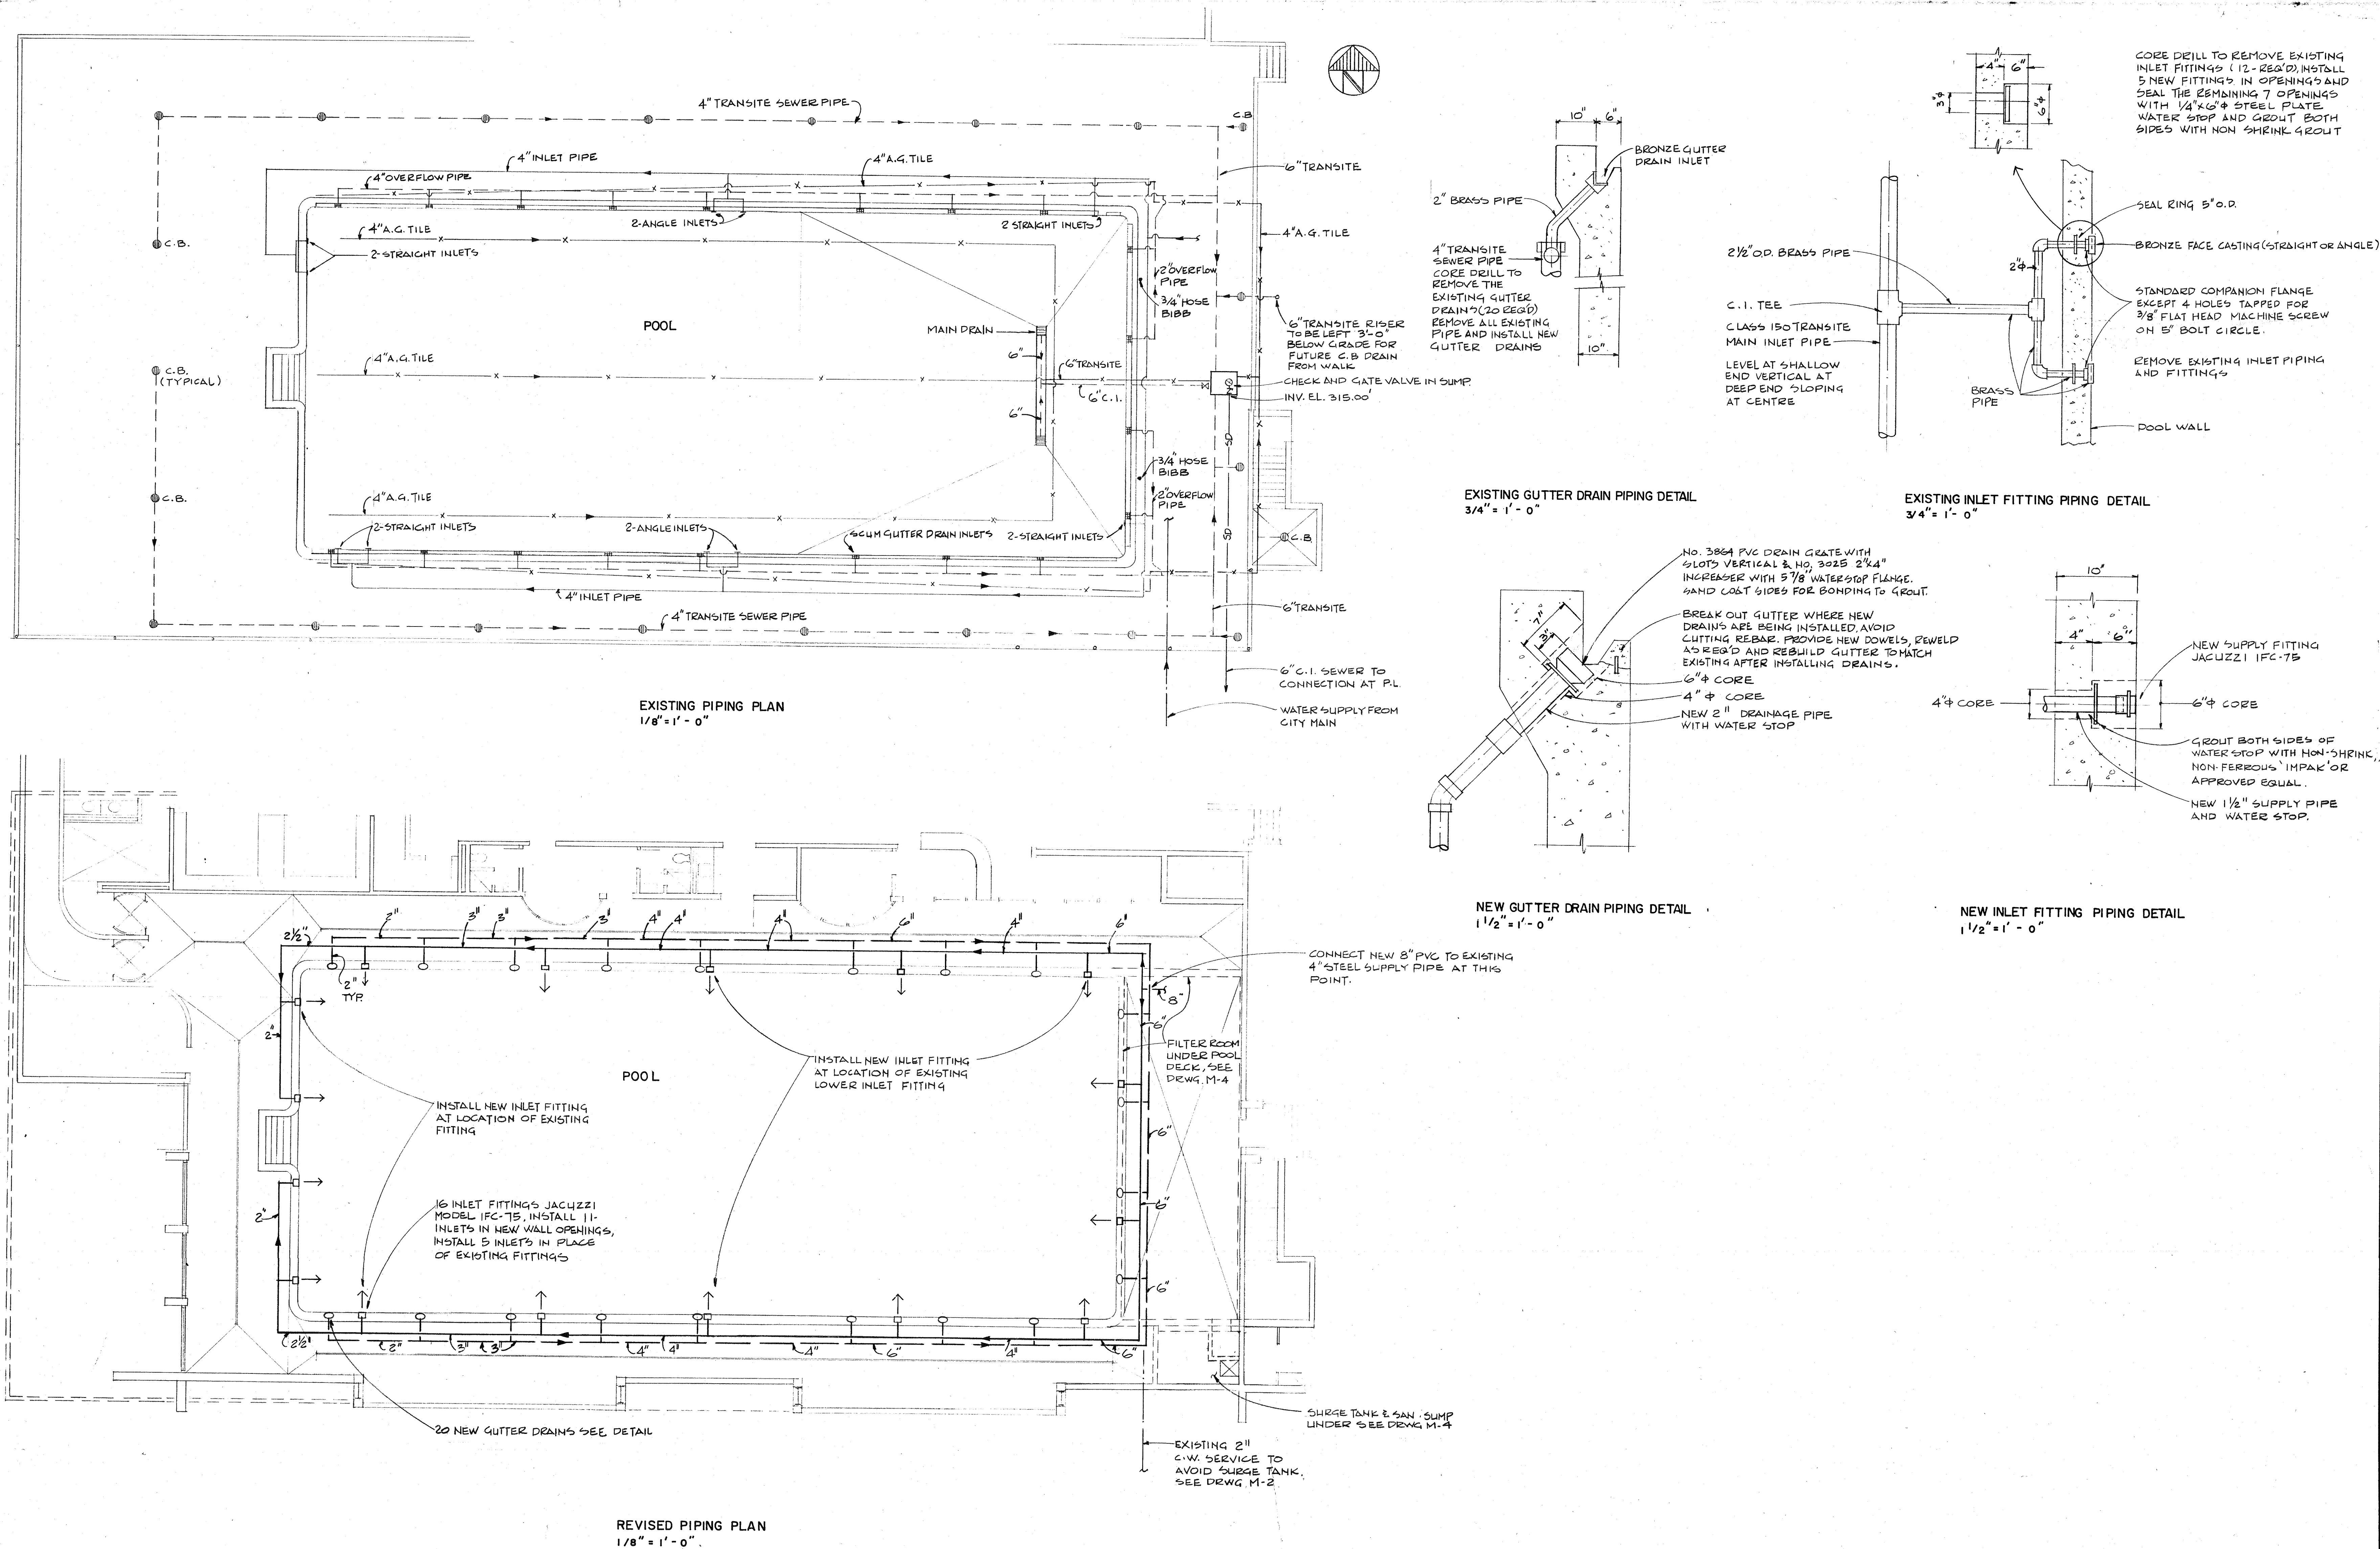

REV.	DATE	BY	DESCRIPTION				
"AS-BUILT" DRAWING This drawing is for reference use only. The City of Vancouver does not guarantee nor is responsible for its accuracy. Users are advised to verify all information on site. CITY OF VANCOUVER BOARD OF PARKS AND RECREATION							
<table border="1"> <tr> <td colspan="4">REVISIONS</td> </tr> </table>				REVISIONS			
REVISIONS							

J. M. BEAN & CO. LTD.
CONSULTING ENGINEERS

1965 WEST 4TH AVENUE
VANCOUVER B.C.
V6J 1M8 736-6724

FILE	7816
DATE	79/07/06



**CARLBERG
JACKSON
PARTNERS**

ARCHITECTS

313 SIXTH STREET
NEW WESTMINSTER
526-2764



TITLE
KERRISDALE
SWIMMING
POOL
ADDITION

5851 W. BOULEVARD
VANCOUVER, B. C.

COMM. NO.	DATE
7815	79/07/06
DRAWN	CHECK

DRAWING TITLE
POOL PIPING PLAN

DRAWING NO.

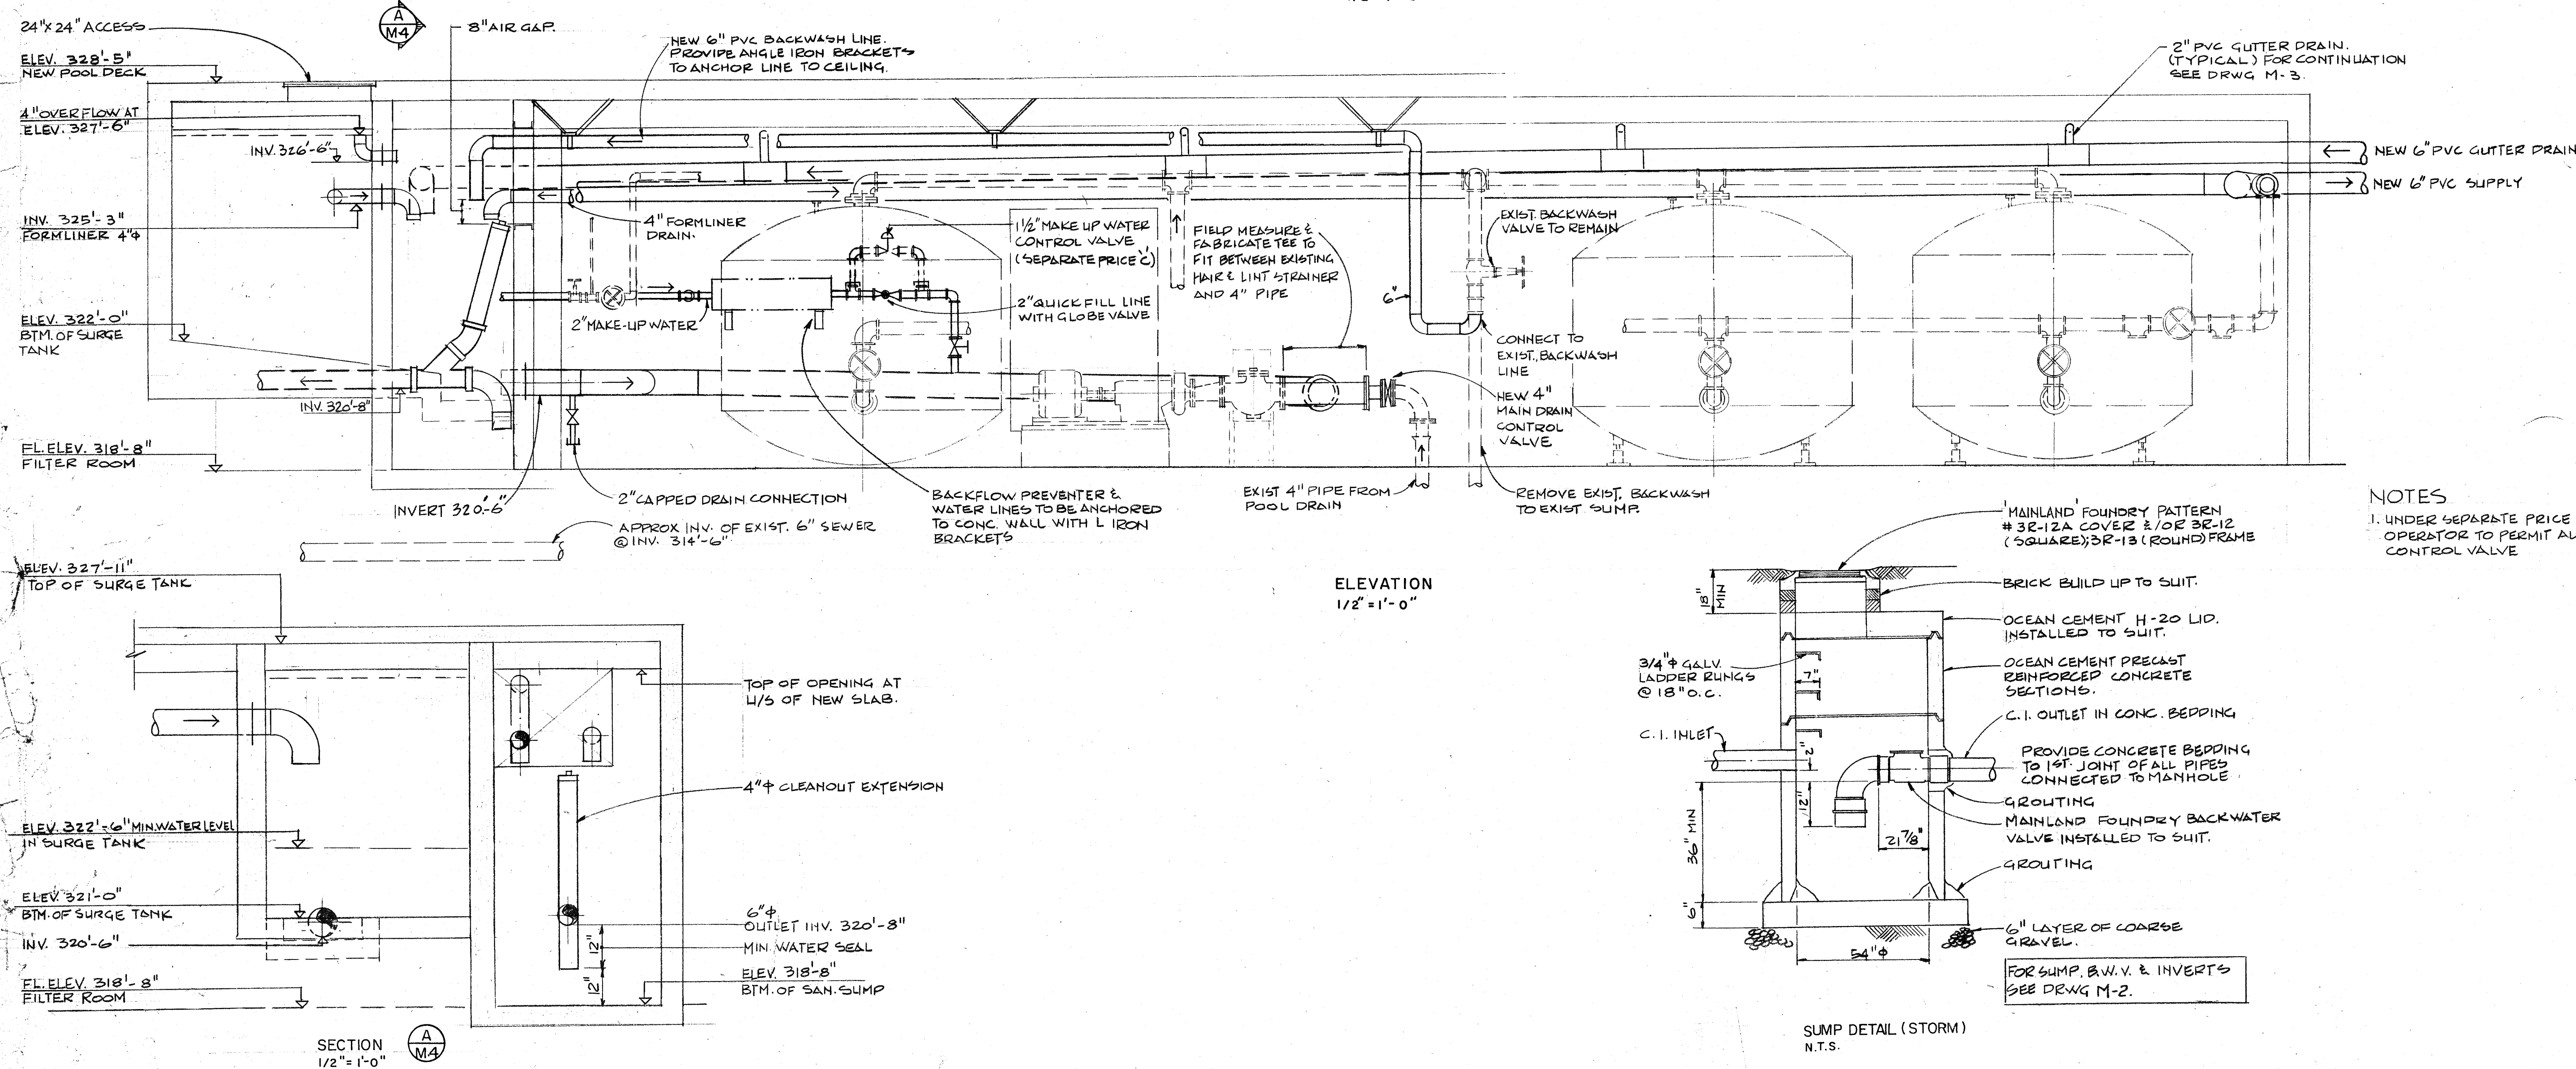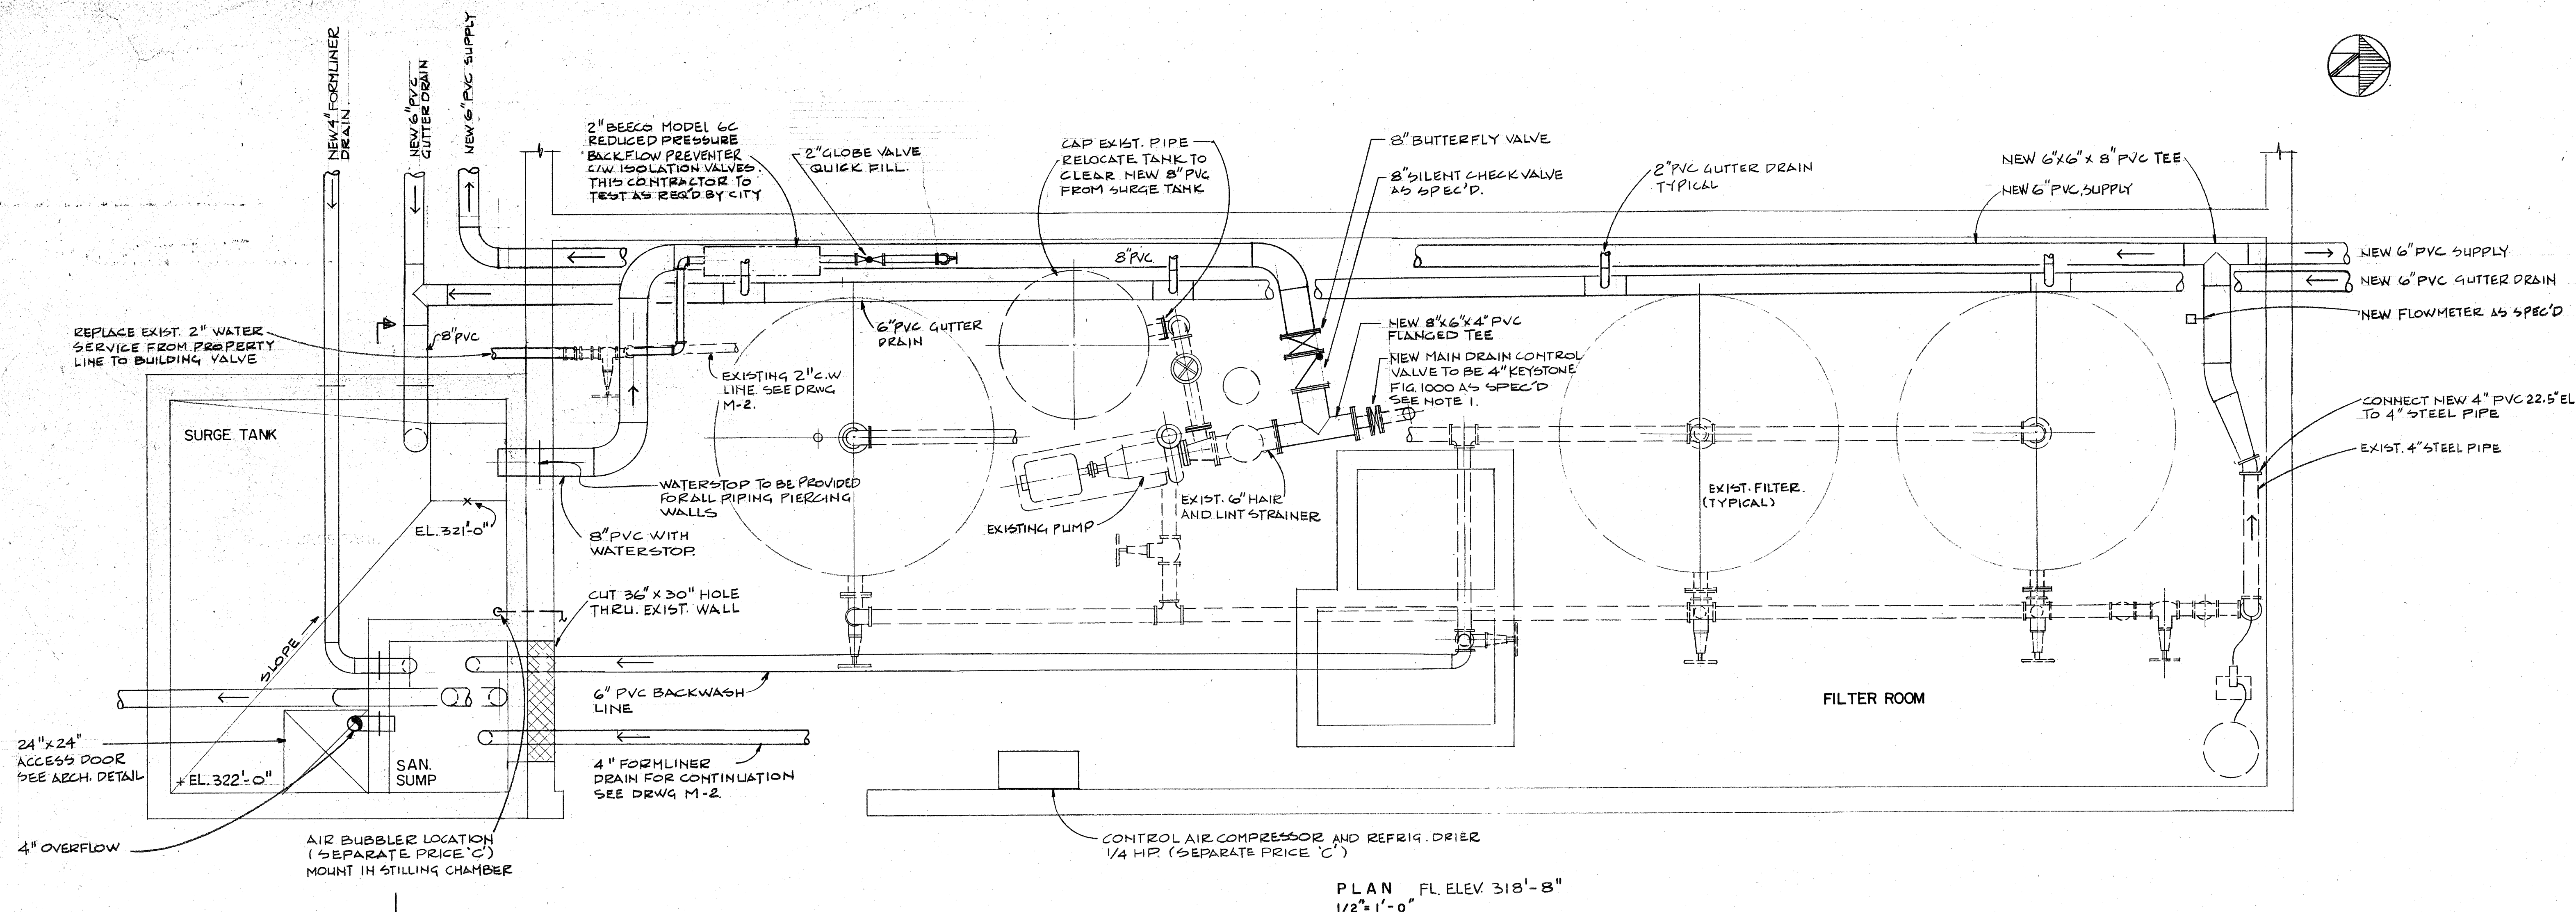

NOTES

1. UNDER SEPARATE PRICE 'C', ADD PNEUMATIC POSITIONER & OPERATOR TO PERMIT AUTOMATIC CONTROL OF THE MAIN DRAIN CONTROL VALVE.

REV. DATE BY DESCRIPTION

"AS-BUILT" DRAWING

This drawing is for reference use only. The City of Vancouver does not guarantee nor is responsible for its accuracy. Users are advised to verify all information on site.

CITY OF VANCOUVER
BOARD OF PARKS AND RECREATION

REVISIONS

J. M. BEAN & CO. LTD.

CONSULTING ENGINEERS

1985 WEST 41st AVENUE
VANCOUVER, B.C.
V6J 1M6 738-6724

FILE 7816
DATE 79/07/06

CARLBERG
JACKSON
PARTNERS

ARCHITECTS

313 SIXTH STREET
NEW WESTMINSTER
S2B-2784

TITLE

KERRISDALE
SWIMMING
POOL
ADDITION

5851 W. BOULEVARD
VANCOUVER, B.C.

COMM. NO. DATE

7815 79/07/06

DRAWN CHECK

SC

DRAWING TITLE

FILTER ROOM PIPING

DRAWING NO.

M-4 OF 4

A0 149.009/04